


**EXISTING CONDITIONS & DEMO PLAN**  
 3/16"=1'-0"

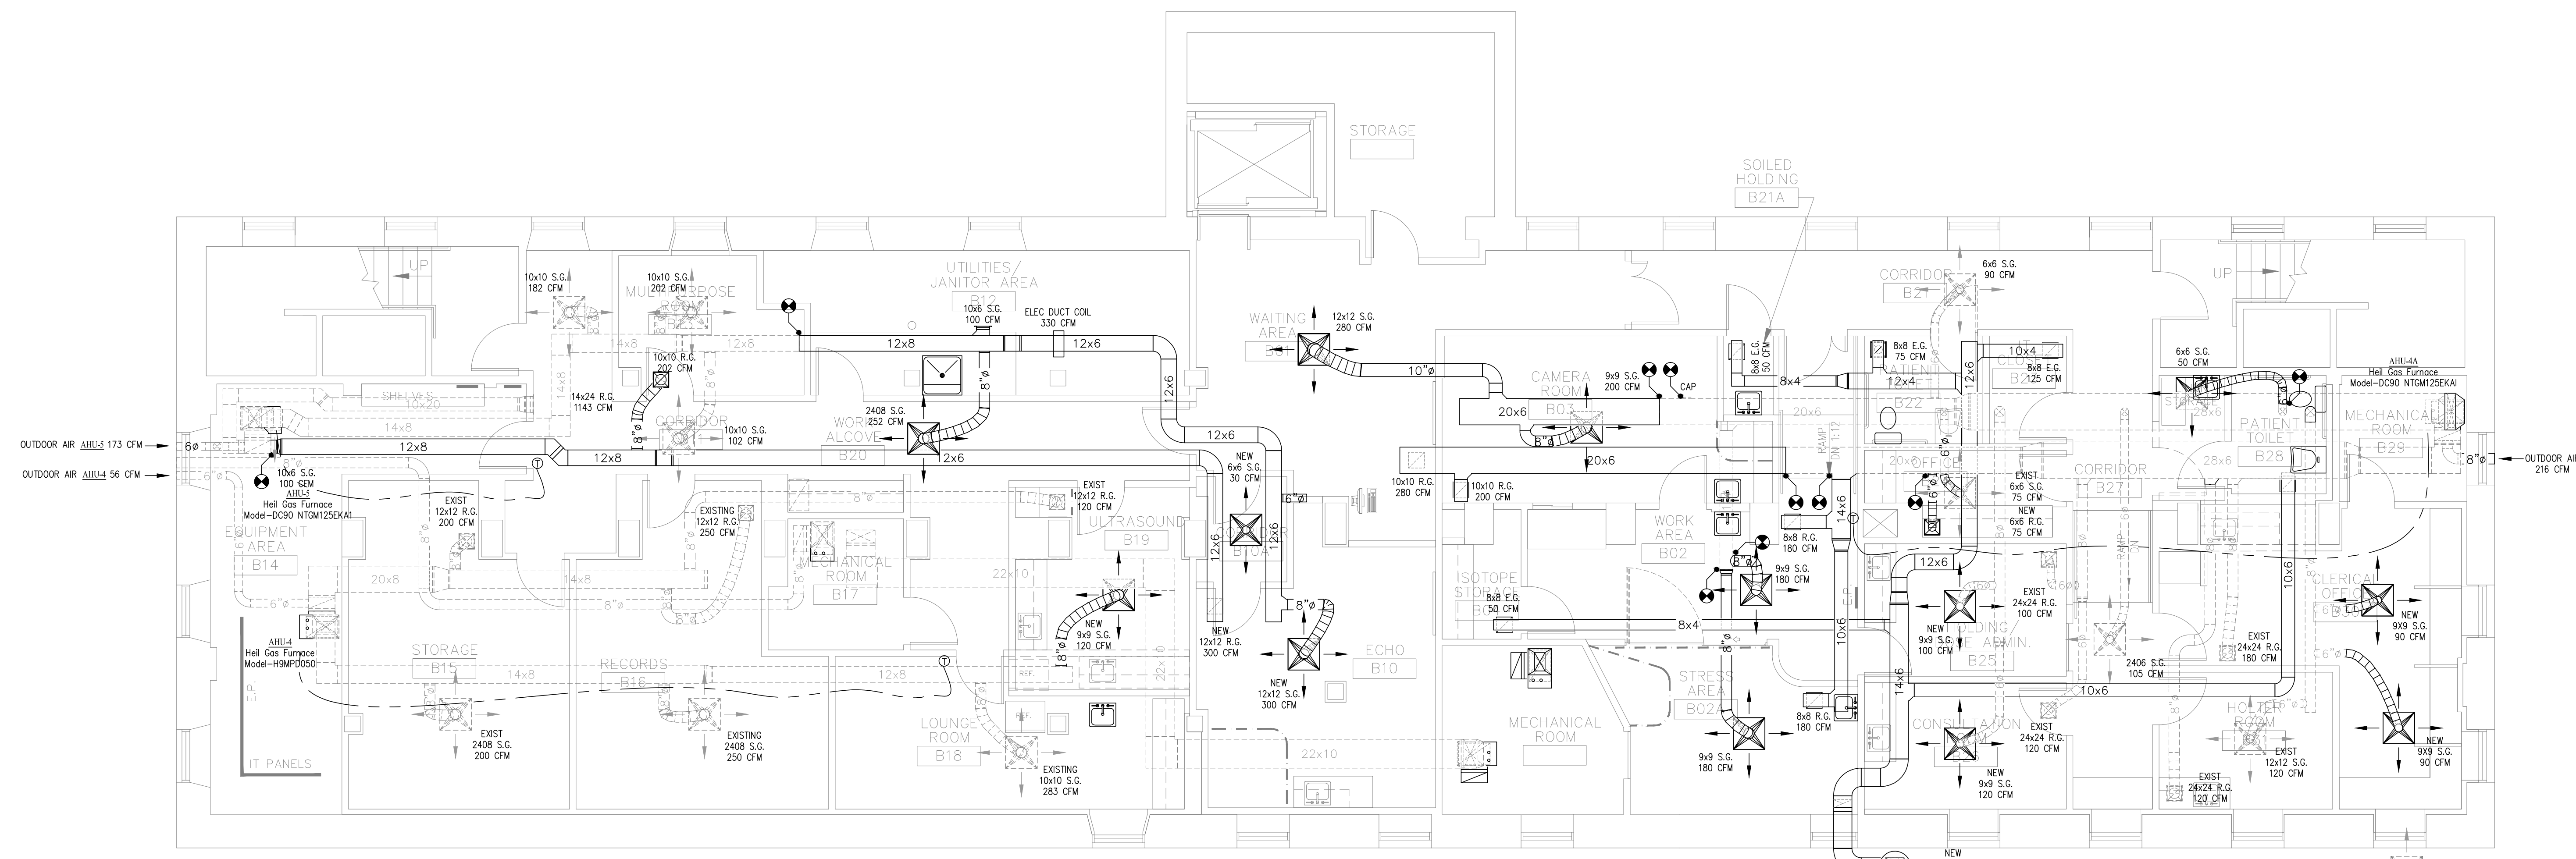

**PROPOSED HVAC PLAN**  
 3/16"=1'-0"

Notes

No.	Revisions/Submissions	Date
0	ISSUED FOR REVIEW	9-27-11

Key Plan

Facility	BAYSTATE	Project No.	T-11-281
Location	CARDIOVASCULAR IMAGING		
	10 MAIN STREET		
	FLORENCE, MA 01062		
Project Title	CARDIOVASCULAR IMAGING		
Drawing Title	FIRST FLOOR		
	HVAC MODIFICATIONS		

Approvals	Date

Drawn By	CJC	Date	9-28-11
----------	-----	------	---------

Checked By		Scale	3/16"=1'-0"
------------	--	-------	-------------

CAO File	
----------	--

Seal	Drawing No.



