

David H. Dunlap Associates Inc.
 ARCHITECTS * ENGINEERS * PLANNERS
 105 WEBSTER STREET UNIT 2
 HANOVER, MASSACHUSETTS 02339
 PHONE: (781) 878-0066 FAX: (781) 878-7060
 E-MAIL: David@DHDunlap.com
 BID DATE: 8/23/11




Proposed Electrical Partial First Floor Plan
 EAST LONGMEADOW SKILLED NURSING CENTER
 EAST LONG MEADOW, MA
 PROJECT NO. 10525A-1-REC
 PROJECT DATE: 8/23/2011
 PROJECT TIME: 10:03 AM

SCALE: 1/8"=1'-0"
 DATE: 7/28/11
 DR. BY: P.J.L.

E-1

DHP - SUBMISSION 8/5/11

SITTING
 REQUIRED 414 SF
 PROVIDED 450 SF

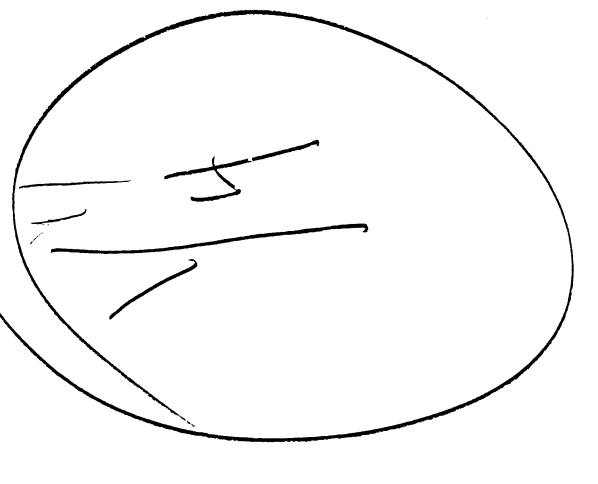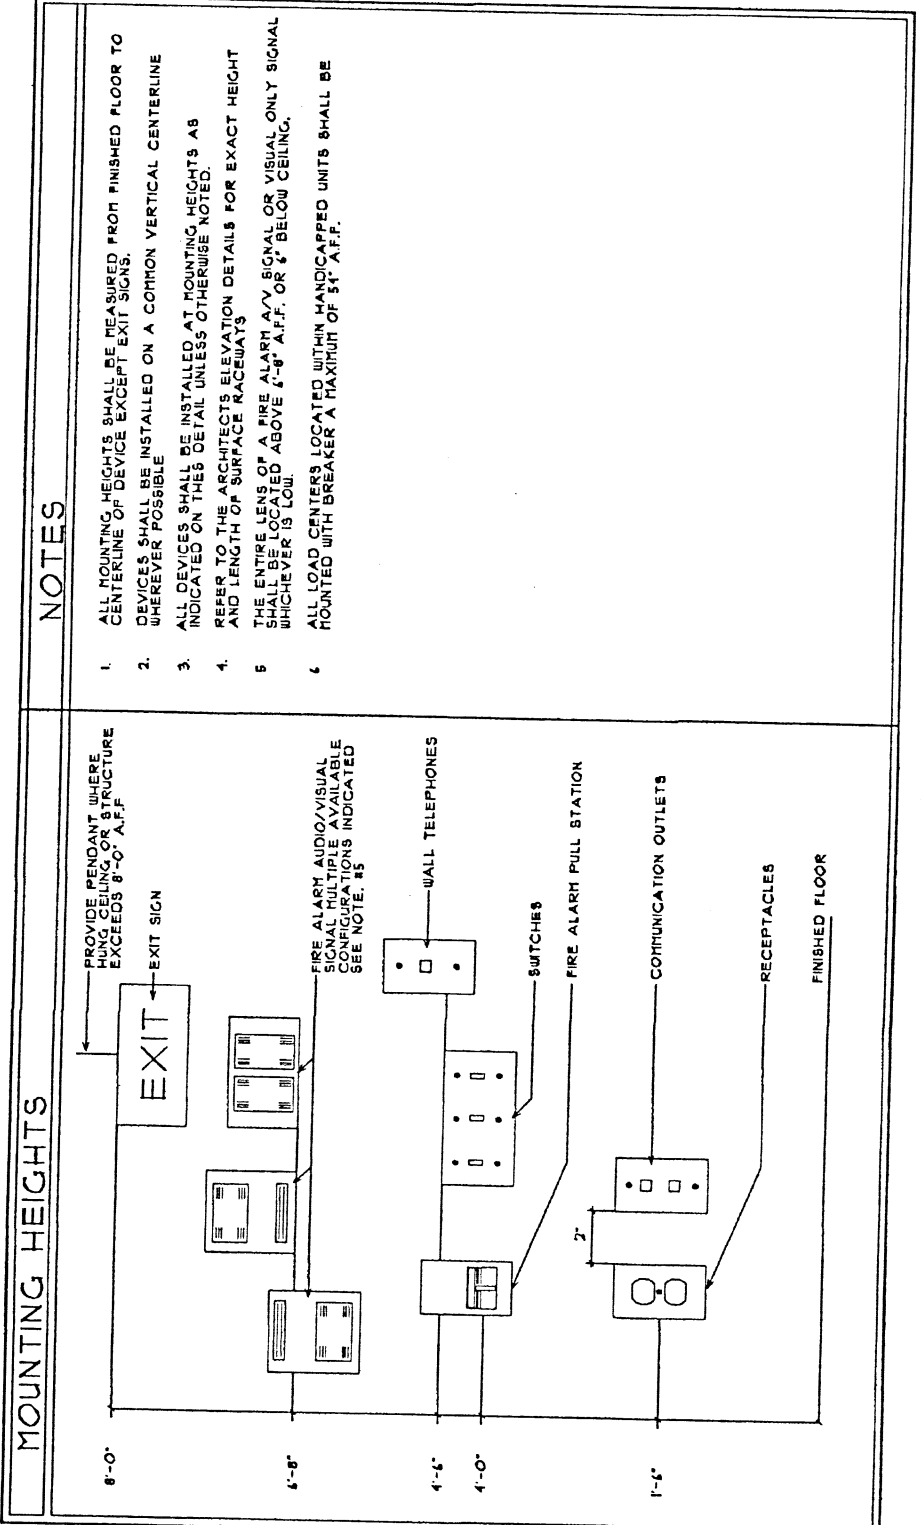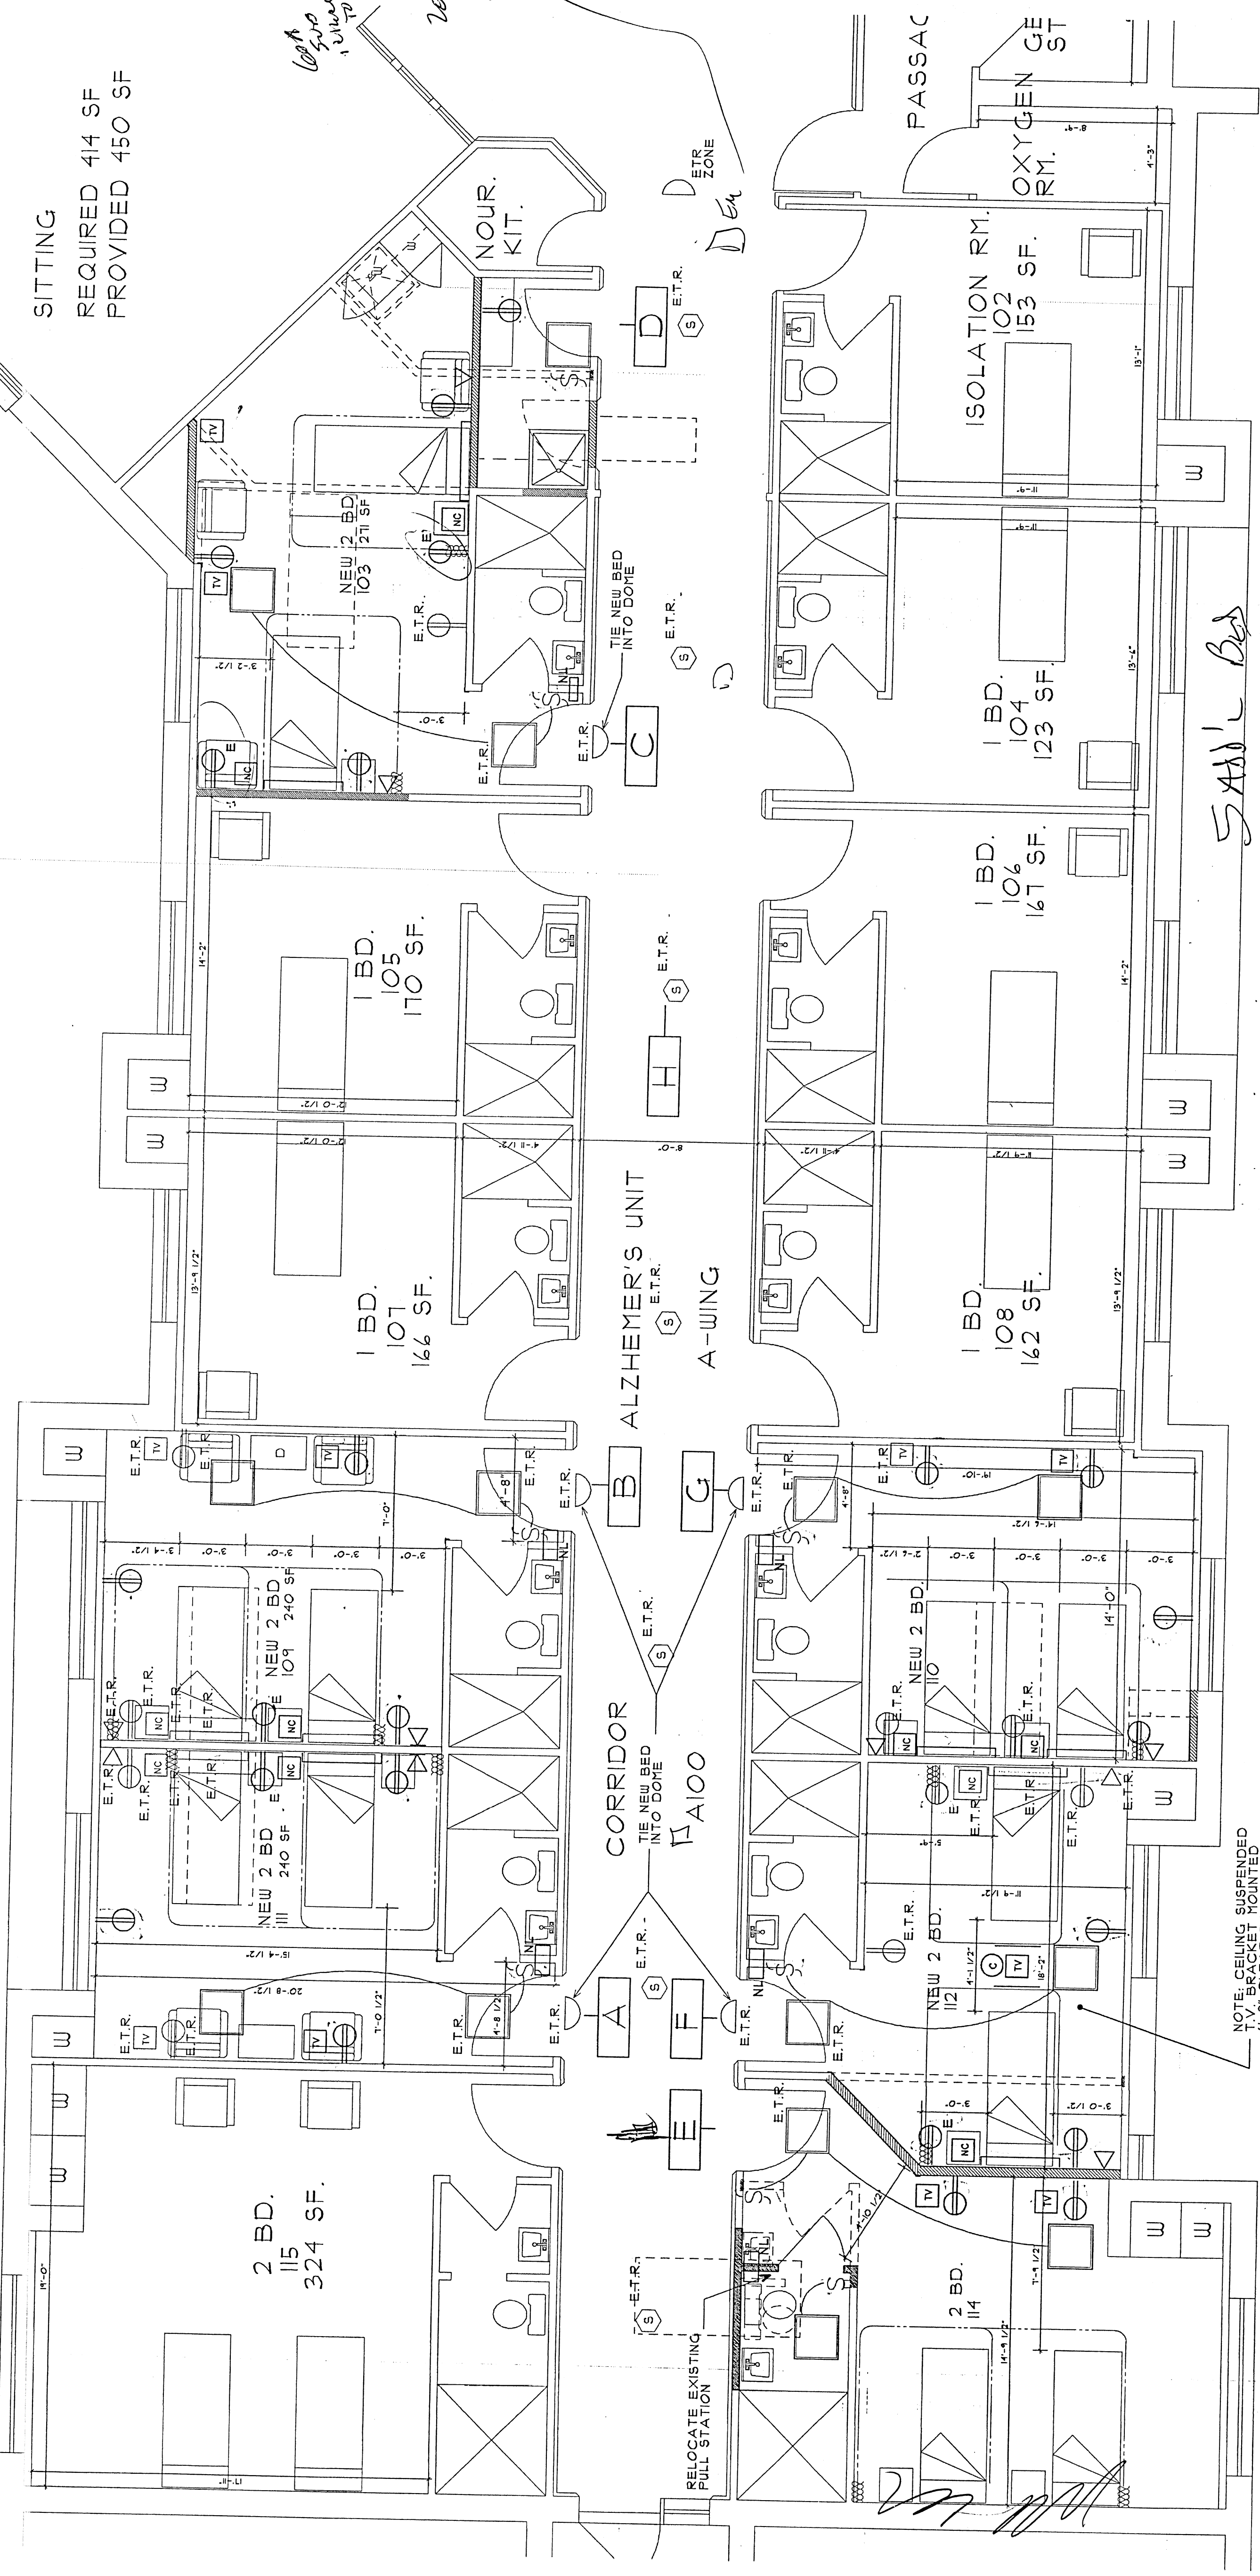

NOTE: CEILING SUSPENDED
 T.V. BRACKET MOUNTED
 TO BE FOR 10"
 DOUBLE FACED FOR 2 T.V.s.

ELEC. LEGEND

⊕	NEW RECEPTACLE MOUNTED @ 1'-8"	⊖	NURSE CALL LIGHT EX. TO REMAIN
⊕	NEW RECEPTACLE MOUNTED @ 4'-0" TIE TO EMERGENCY CIRCUIT	⊕	NEW TEL/DATA OUTLET
⊕	EXISTING RECEPTACLE EX. TO REMAIN	⊕	NEW THRU WALL NIGHT LIGHT DOUBLE LENSE
⊕	NEW CEILING MOUNTED RECEPTACLE	⊕	NEW TELEVISION POWER AND CABLE CONNECTION
⊕	NURSES CALL EX. TO REMAIN	⊕	TELEVISION POWER AND CABLE CONNECTION EX. TO REMAIN
⊕	NEW NURSES CALL	⊕	1' WALL MOUNTED LIGHT
⊕	LIGHT SWITCH		

- NOTES**
1. ALL WORK SHALL BE IN ACCORDANCE WITH THE 2011 MASSACHUSETTS ELECTRICAL CODE.
 2. ALL WORK SHALL BE IN ACCORDANCE WITH THE 2011 MASSACHUSETTS MECHANICAL CODE.
 3. ALL WORK SHALL BE IN ACCORDANCE WITH THE 2011 MASSACHUSETTS PLUMBING CODE.
 4. ALL WORK SHALL BE IN ACCORDANCE WITH THE 2011 MASSACHUSETTS GAS CODE.
 5. ALL WORK SHALL BE IN ACCORDANCE WITH THE 2011 MASSACHUSETTS FIRE ALARM AND SIGNALING CODE.
 6. ALL WORK SHALL BE IN ACCORDANCE WITH THE 2011 MASSACHUSETTS COMMUNICATIONS CODE.
 7. ALL WORK SHALL BE IN ACCORDANCE WITH THE 2011 MASSACHUSETTS BUILDING CODE.