 
 


- AUTOMATIC INITIATION
- MANUAL INITIATION
- WATER FLOW - A/B
- WATER FLOW - C/D
- CARBON MONOXIDE
- MASTER BOX
- TROUBLE
- SUPERVISORY



MAINTENANCE

- AUTOMATIC INITIATION
- MANUAL INITIATION
- WATER FLOW
- TROUBLE
- SUPERVISORY
- CARBON MONOXIDE

 


REGIONAL HOLDING FACILITY

- AUTOMATIC INITIATION
- MANUAL INITIATION
- WATER FLOW
- TROUBLE
- CARBON MONOXIDE
- ALARM
- TROUBLE
- SUPERVISORY


(IF SIMPLEX SYSTEM IS PROVIDED)

(IF SIMPLEX SYSTEM IS NOT PROVIDED)




HOUSING/MINIMUM SECURITY

 - AUTOMATIC INITIATION
- MANUAL INITIATION
- WATER FLOW
- TROUBLE
- SUPERVISORY
- CARBON MONOXIDE



MODULAR BUILDING

- ALARM
- TROUBLE
- SUPERVISORY

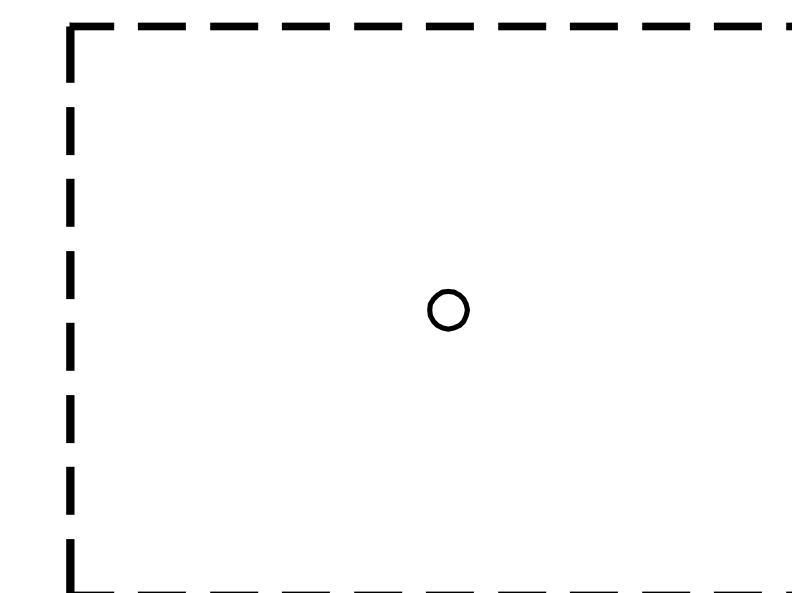

FUTURE BUILDING

- AUTOMATIC INITIATION
- MANUAL INITIATION
- WATER FLOW
- TROUBLE
- CARBON MONOXIDE

**NOTES:**

1. PROVIDE FLUSH GRAPHIC ANNUNCIATOR WITH LED PUSH-TO-TEST INDICATORS AND PUSH BUTTONS.
2. THE FIRE ALARM SYSTEM SHALL SOURCE THE REQUIRED 24V DC FOR THE "PUSH TO TEST" LED INDICATORS.
3. THE ADDRESSABLE CONTROL MODULES AND MONITORING MODULES SHALL BE MOUNTED INSIDE THE ANNUNCIATOR HOUSING. PROVIDE ALL NECESSARY CONTROL AND MONITORING MODULES TO ACTIVATE ALL EQUIPMENT AND INDICATORS. ALL DEVICES NOT ILLUSTRATED ON FLOOR PLANS.

REVISIONS			HAMPSHIRE COUNTY SHERIFF'S DEPT. PROJECT NO. 20945A	CONTRACT NO. HSD FY12-05
NO.	DESCRIPTION	DATE	FIRE ALARM UPGRADES & REPLACEMENT	
DD	DESIGN DEVELOPMENT	6/30/11	HAMPSHIRE COUNTY HOUSE OF CORRECTIONS	
CD	95% CONSTRUCTION DOCUMENTS	12/06/11	THE COMMONWEALTH OF MASSACHUSETTS	
CD	BID DOCUMENTS	12/28/11	HAMPSHIRE COUNTY SHERIFF'S DEPARTMENT	
			ROCKY HILL ROAD NORTHAMPTON, MA 01060	
			DIETZ AND COMPANY ARCHITECTS, INC.	
			17 HAMPODEN STREET	
			SPRINGFIELD, MA 01103	
			<b>FIRE ALARM DETAILS</b>	
DRAWN:		SCALE: NTS	<b>FA 400</b>	
CHECKED: KIG		DATE: 12/28/11		

