



# UNIVERSITY OF MASSACHUSETTS AMHERST, MA

## Morrill II & III Ventilation Upgrade

25 AUGUST 2010 - BID DATE  
UMA CONTRACT # 11-04

### Fitzmeyer & Tucci Associates, Inc.

**Lead Designer - Engineering**  
52 Montvale Ave., Suite 4100, Stoneham, MA 02180  
Phone: 781-481-0210  
Fax: 781-481-0203  
**Ted Fitzmeyer, PE, Principal**  
**Steve Montibello, PE, Principal**  
Adam Leonard, Mechanical Engineer, Project Manager  
tfit@f.com; smontibello@f.com; aleonard@f.com

Engineer Stamp

Engineer Stamp

### Facilities Planning

**Capital Project Manager**  
University of Massachusetts Amherst  
360 Campus Center Way  
Phone: 413-545-3884  
Thomas D. Shaw, P.E., Associate Director for Design and Construction  
Phone: 413-545-6499  
dstshaw@facil.umass.edu  
Richard P. Nathorst, Capital Project Manager  
Phone: 413-545-6497  
RNathorst@facil.umass.edu

Engineer Stamp

Engineer Stamp

### Paul DiBona Specifications, LLC

**Specifications Writer**  
108 Hayden Rowe St., Hopkinton, MA 01748-2808  
Phone: 508-625-1098  
Fax: 508-686-8839  
Paul DiBona, President  
paul@pdspecs.com

Engineer Stamp

### Civitects, PC

**Architect**  
249 Main Street, Wareham, MA 02571  
Phone: 508-291-0050  
Fax: 508-291-0153  
**Michael Keane, AIA, Project Architect**  
mkeane@civitects.com

Architect Stamp

### I v Consulting Engineers, Inc.

**Structural Engineer**  
20 North Rd., Bedford, MA 01730  
Phone: 781-275-2219  
Fax: 781-275-4462  
Uy Thanh Ly, PE  
uly@ivcon-engineers.com

Engineer Stamp

### ATC Associates, Inc.


**Industrial Hygienist**  
138 Tilda Hill Rd., Florida, MA 01247  
Phone: 413-664-6687  
Fax: 413-781-3724  
**Derrick Wissman, Senior Project Manager**  
derrick.wissman@atcassociates.com

### PM&C

**COST ESTIMATOR**  
59 SOUTH STREET, HINGHAM, MA 02043  
PHONE: 781-740-8007  
FAX: 781-740-1012  
**PETER BRADLEY, PRESIDENT**  
PETERBRADLEY@PMC-MA.COM



LOCUS PLAN

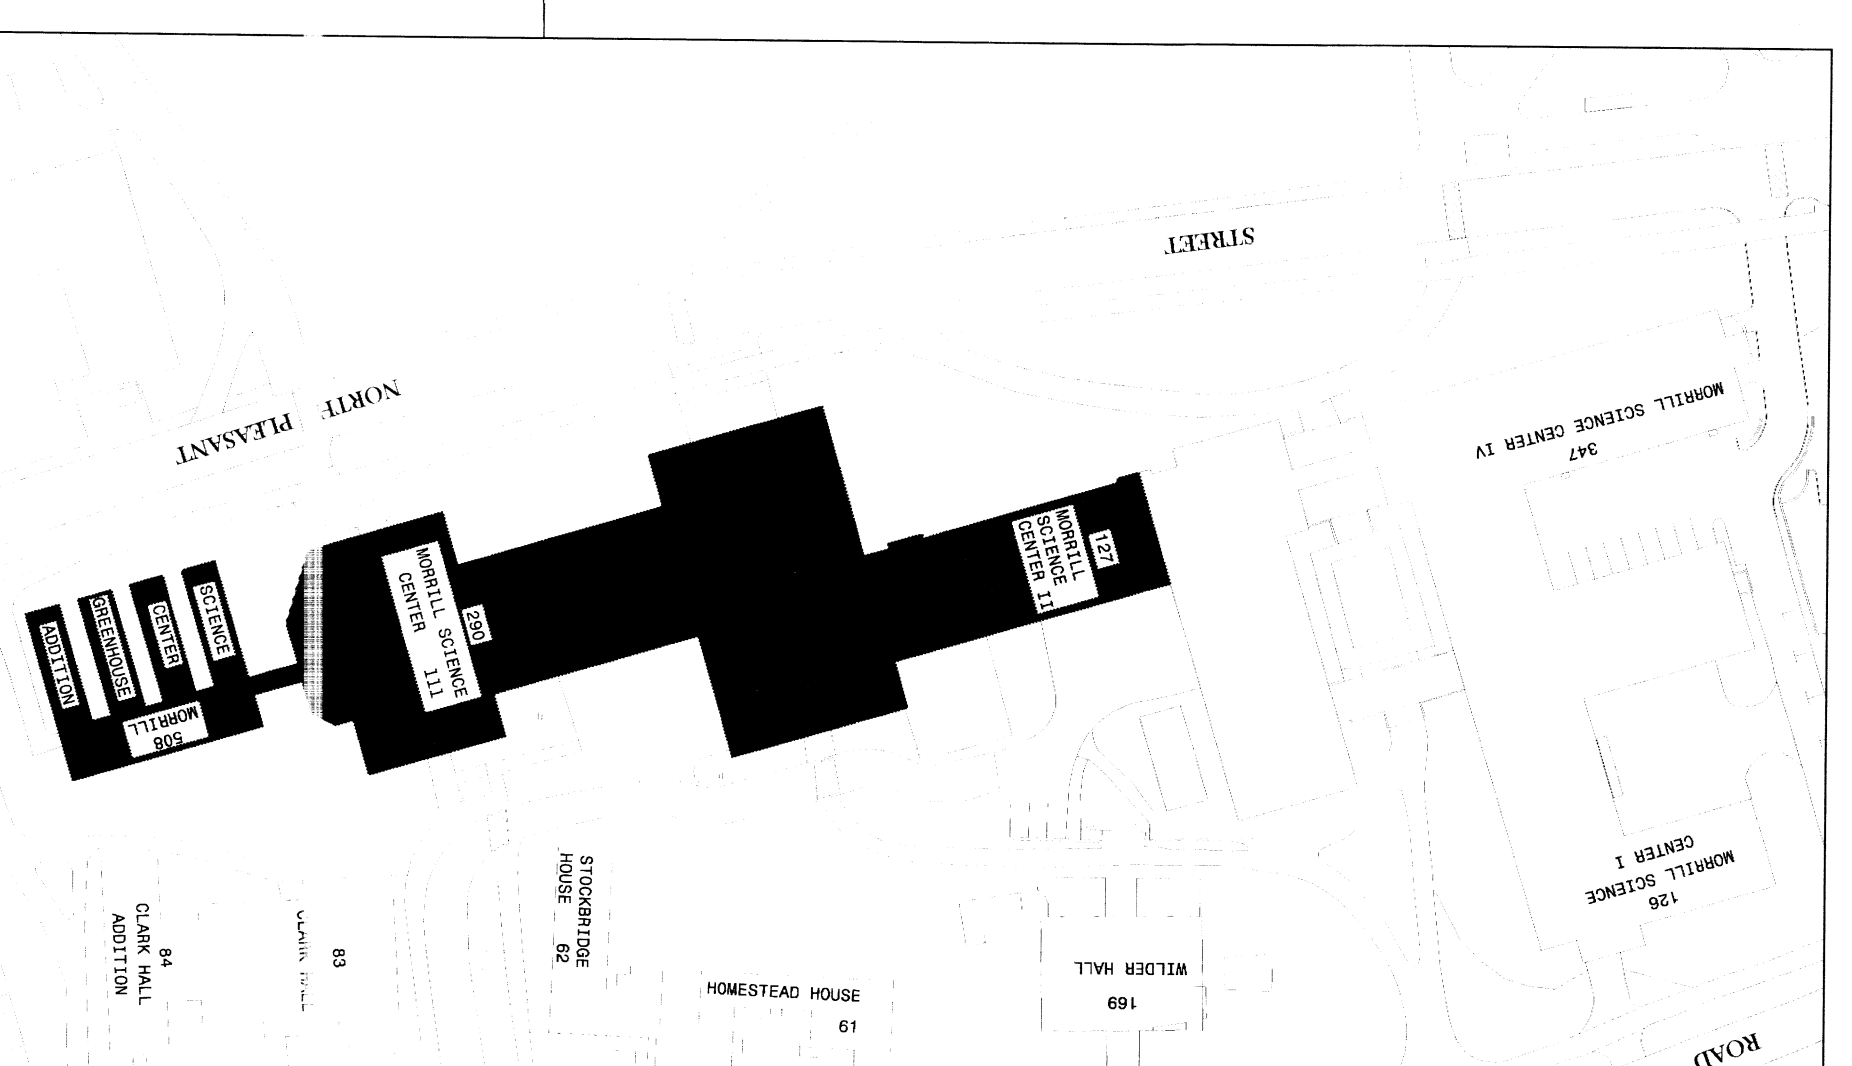

MORRILL LOCATION PLAN

#### 10 LIST OF DRAWINGS T1 - TITLE SHEET

- ARCHITECTURAL**  
A1 - MORRILL 2&3, FIRST FLOOR PLAN  
A2 - MORRILL 2&3, FIRST FLOOR REFLECTED CEILING PLAN  
A3 - MORRILL 2, SECOND FLOOR PLAN  
A4 - MORRILL 2, SECOND FLOOR REFLECTED CEILING PLAN  
A5 - MORRILL 3, SECOND FLOOR PLAN  
A6 - MORRILL 3, SECOND FLOOR REFLECTED CEILING PLAN  
A7 - MORRILL 2&3, THIRD FLOOR PLAN  
A8 - MORRILL 2, FOURTH FLOOR REFLECTED CEILING PLAN  
A9 - MORRILL 2, FOURTH FLOOR REFLECTED CEILING PLAN  
A10 - MORRILL 2, FOURTH FLOOR REFLECTED CEILING PLAN  
A11 - MORRILL 3, FOURTH FLOOR REFLECTED CEILING PLAN  
A12 - MORRILL 3, FOURTH FLOOR REFLECTED CEILING PLAN  
A13 - MORRILL 2, DEMOLITION ROOF PLAN  
A14 - MORRILL 3, DEMOLITION ROOF PLAN  
A15 - MORRILL 2, ROOF PLAN  
A16 - MORRILL 3, ROOF PLAN  
A17 - ROOF DEMOLITION DETAILS  
A18 - ROOF DETAILS  
A19 - ROOF DETAILS  
A20 - ROOF DUNNAGE DETAILS  
A21 - LOUVER DETAILS  
A22 - DETAILS & ELEVATIONS  
A23 - SECTIONS & INTERIOR ELEVATIONS

- STRUCTURAL**  
S1 - GENERAL NOTES  
S2 - SECTIONS & DETAILS  
S3 - MORRILL 2&3, PARTIAL STRUCTURAL FIRST FLOOR PLANS  
S4 - MORRILL 2, PARTIAL STRUCTURAL SECOND & THIRD FLOOR PLANS  
S5 - MORRILL 2, STRUCTURAL FOURTH FLOOR PLAN  
S6 - MORRILL 3, STRUCTURAL FOURTH FLOOR PLAN  
S7 - MORRILL 2, STRUCTURAL ROOF PLAN  
S8 - MORRILL 3, STRUCTURAL ROOF PLAN  
S9 - MORRILL 2, DETAILS DUNNAGE NO. 1  
S10 - MORRILL 3, DETAILS DUNNAGE NO. 2

- PLUMBING**  
P0 - PLUMBING LEGEND, DETAILS AND SCHEDULES  
P1 - PLUMBING FIRST FLOOR PLAN  
P2 - PLUMBING SECOND FLOOR PLAN  
P3 - PLUMBING THIRD FLOOR PLAN  
P4 - PLUMBING FOURTH FLOOR PLAN

- MECHANICAL**  
M0 - MECHANICAL LEGEND  
M1 - MORRILL 3, MECHANICAL BASEMENT PLAN  
M2 - MORRILL 2, MECHANICAL FIRST FLOOR PLAN  
M3 - MORRILL 3, MECHANICAL FIRST FLOOR PLAN  
M4 - MORRILL 2, MECHANICAL SECOND FLOOR PLAN  
M5 - MORRILL 3, MECHANICAL SECOND FLOOR PLAN  
M6 - MORRILL 2, MECHANICAL SECOND FLOOR PLAN  
M7 - MORRILL 3, MECHANICAL THIRD FLOOR PLAN  
M8 - MORRILL 2, MECHANICAL FOURTH FLOOR PLAN  
M9 - MORRILL 3, MECHANICAL FOURTH FLOOR PLAN  
M10 - MORRILL 2, MECHANICAL ROOF PLAN  
M11 - MORRILL 3, MECHANICAL ROOF PLAN  
M12 - MECHANICAL GREENHOUSE PLAN  
M13 - MECHANICAL DETAILS I  
M14 - MECHANICAL DETAILS II  
M15 - MECHANICAL DETAILS III  
M16 - MECHANICAL RISERS  
M17 - MECHANICAL CONTROLS SCHEMATICS  
M18 - MECHANICAL SCHEDULES

- ELECTRICAL**  
E0 - ELECTRICAL LEGEND  
E1 - MORRILL 2, ELECTRICAL RISER DIAGRAM & SCHEDULES  
E2 - MORRILL 2, ELECTRICAL FIRST FLOOR PLAN  
E3 - MORRILL 3, ELECTRICAL FIRST FLOOR PLAN  
E4 - ELECTRICAL GREENHOUSE PLAN  
E5 - MORRILL 2, ELECTRICAL SECOND FLOOR PLAN  
E6 - MORRILL 3, ELECTRICAL SECOND FLOOR PLAN  
E7 - MORRILL 2, ELECTRICAL THIRD FLOOR PLAN  
E8 - MORRILL 3, ELECTRICAL THIRD FLOOR PLAN  
E9 - MORRILL 2, ELECTRICAL FOURTH FLOOR PLAN  
E10 - MORRILL 3, ELECTRICAL FOURTH FLOOR PLAN  
E11 - MORRILL 2, ELECTRICAL ROOF PLAN  
E12 - MORRILL 3, ELECTRICAL ROOF PLAN

REV. NO.	DESCRIPTION	BY	APP'D	DATE
	ISSUED FOR BID			08/25/10
	100% CONSTRUCTION DOCUMENTS SET			08/20/10

**UNIVERSITY OF MASSACHUSETTS**  
FACILITIES PLANNING DIVISION

MORRILL II AND III  
VENTILATION UPGRADE  
PROJECT TITLE SHEET

BY	DATE	PROJECT NO.	CONTRACT NO.
DRN		0803035801	UMA1104
APP'D		SCALE: N/A	SHEET 7 OF 7
CHKD		DRAWING NUMBER	
APP'D		D-A-127/290-08-001594-T1	