

MORRILL II ROOMS 336 / 338

RENOVATIONS

UNIVERSITY OF MASSACHUSETTS AMHERST, MA

BID SET
NOVEMBER 19, 2010
UMA 11-22

ARCHITECT

NAULT ARCHITECTS INC.
71 HOPE AVENUE
WORCESTER, MA 01603
508-755-6134
FAX: 508-755-4661

ELECTRICAL ENGINEER

BLW ENGINEERS, INC.
311 GREAT ROAD, P.O. BOX 1551
LITTLETON, MA 01460
978-486-4301
FAX: 978-428-0067

MECHANICAL ENGINEER

VAV INTERNATIONAL, INC.
400 WEST CUMMINGS PARK, SUITE 4700
WOBBURN, MA 01801
781-935-7228
FAX: 781-935-1822

STRUCTURAL ENGINEER


JOHNSON STRUCTURAL ENGINEERING, INC.
30 FAITH AVE.
AUBURN, MA 01501
508-832-3535
FAX: 508-832-3393

HAZARDOUS MATERIALS


ATC ASSOCIATES, INC.
73 WILLIAM FRANKS DRIVE
WEST SPRINGFIELD, MA 01089
781-932-9400
FAX: 781-932-0211

COST ESTIMATOR





VERMEULENS COST CONSULTANTS
470 ATLANTIC AVENUE, 4TH FLOOR
BOSTON, MA 02210
617-273-8430
FAX: 905-787-9116

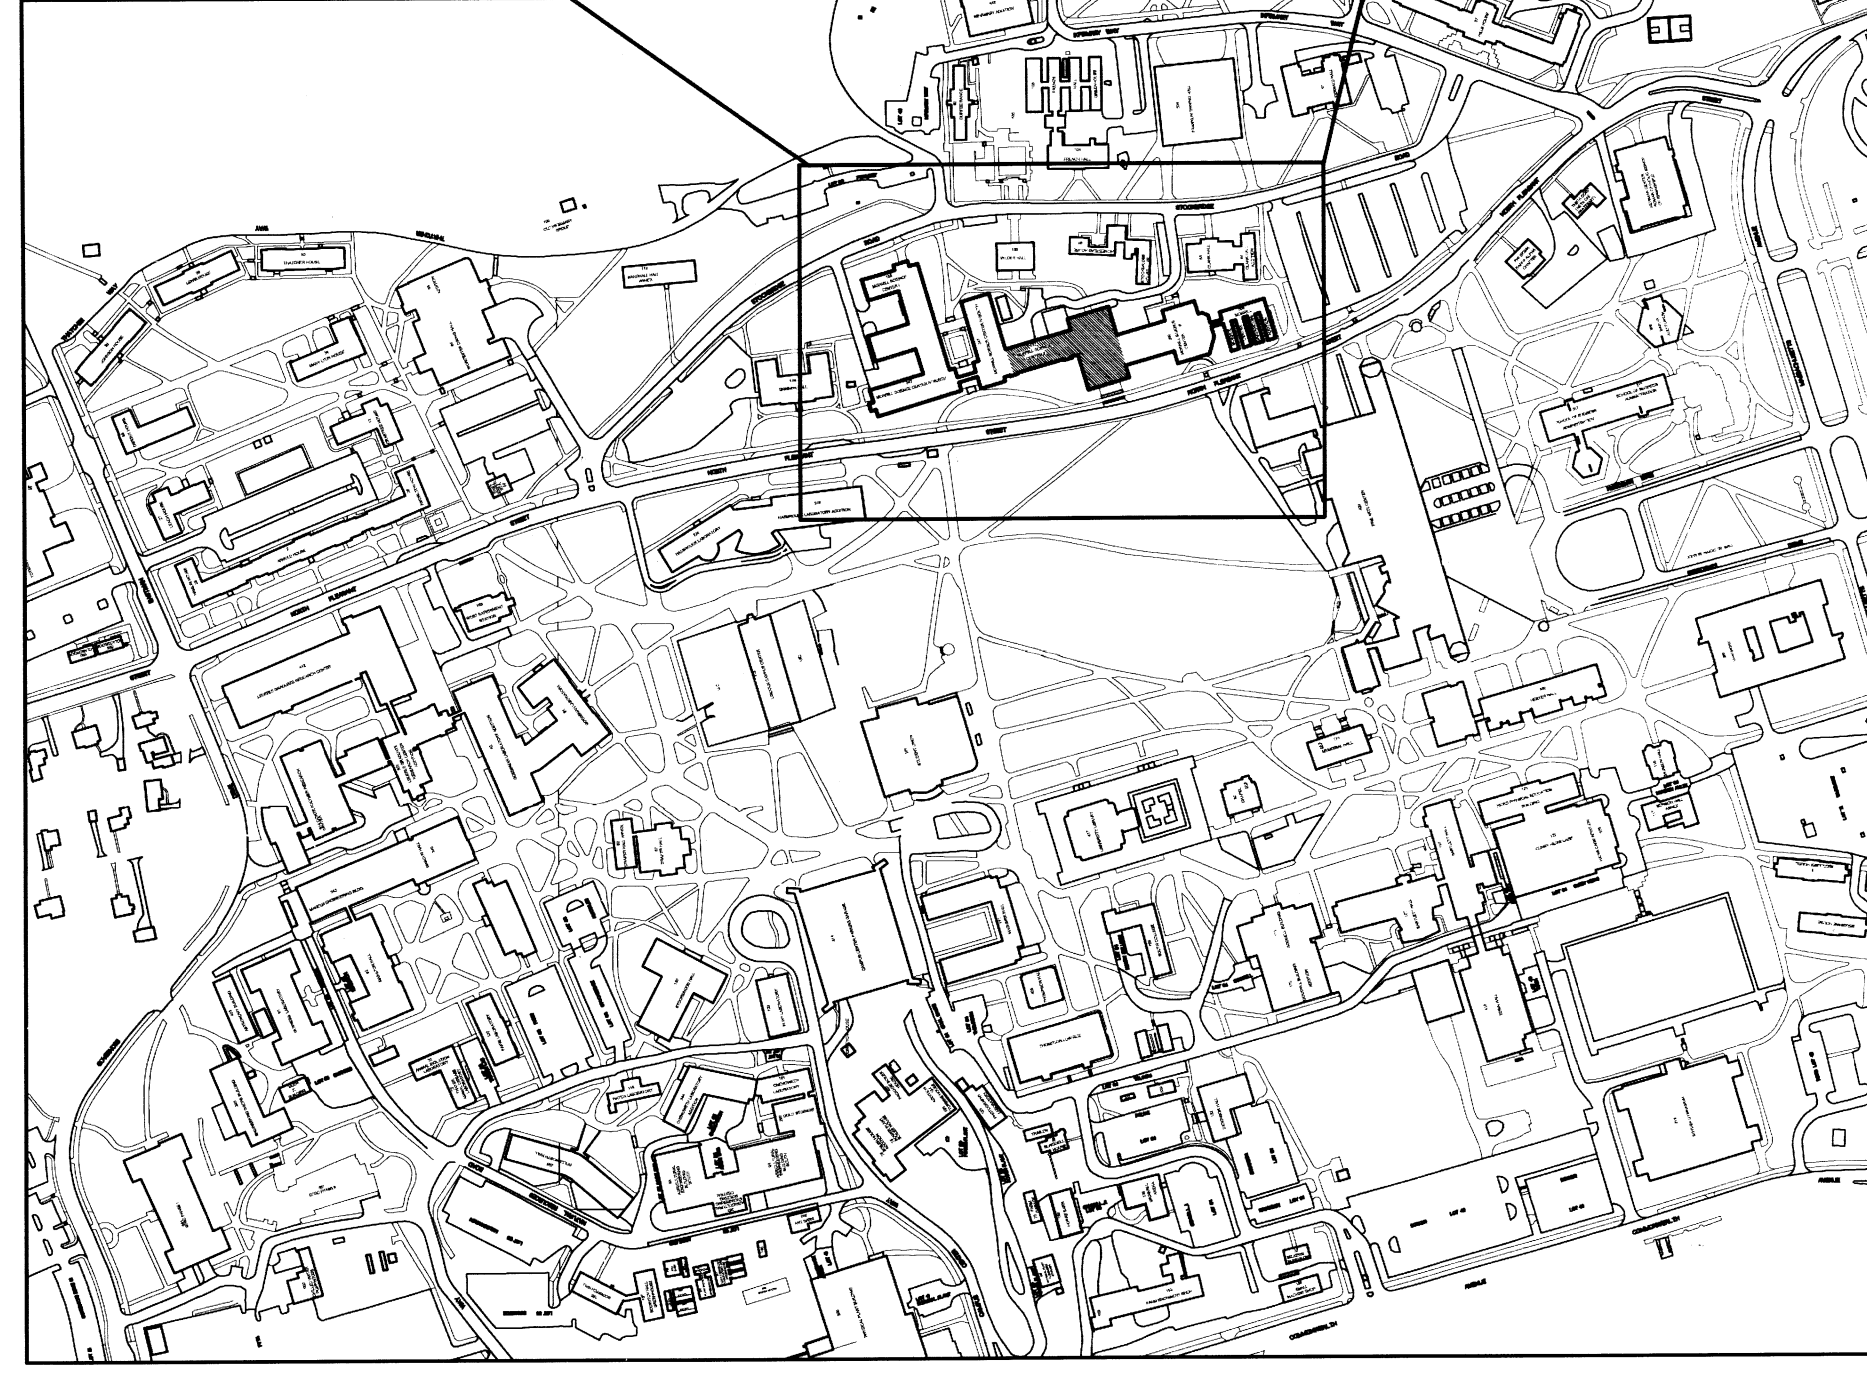

CAMPUS MAP
NOT TO SCALE

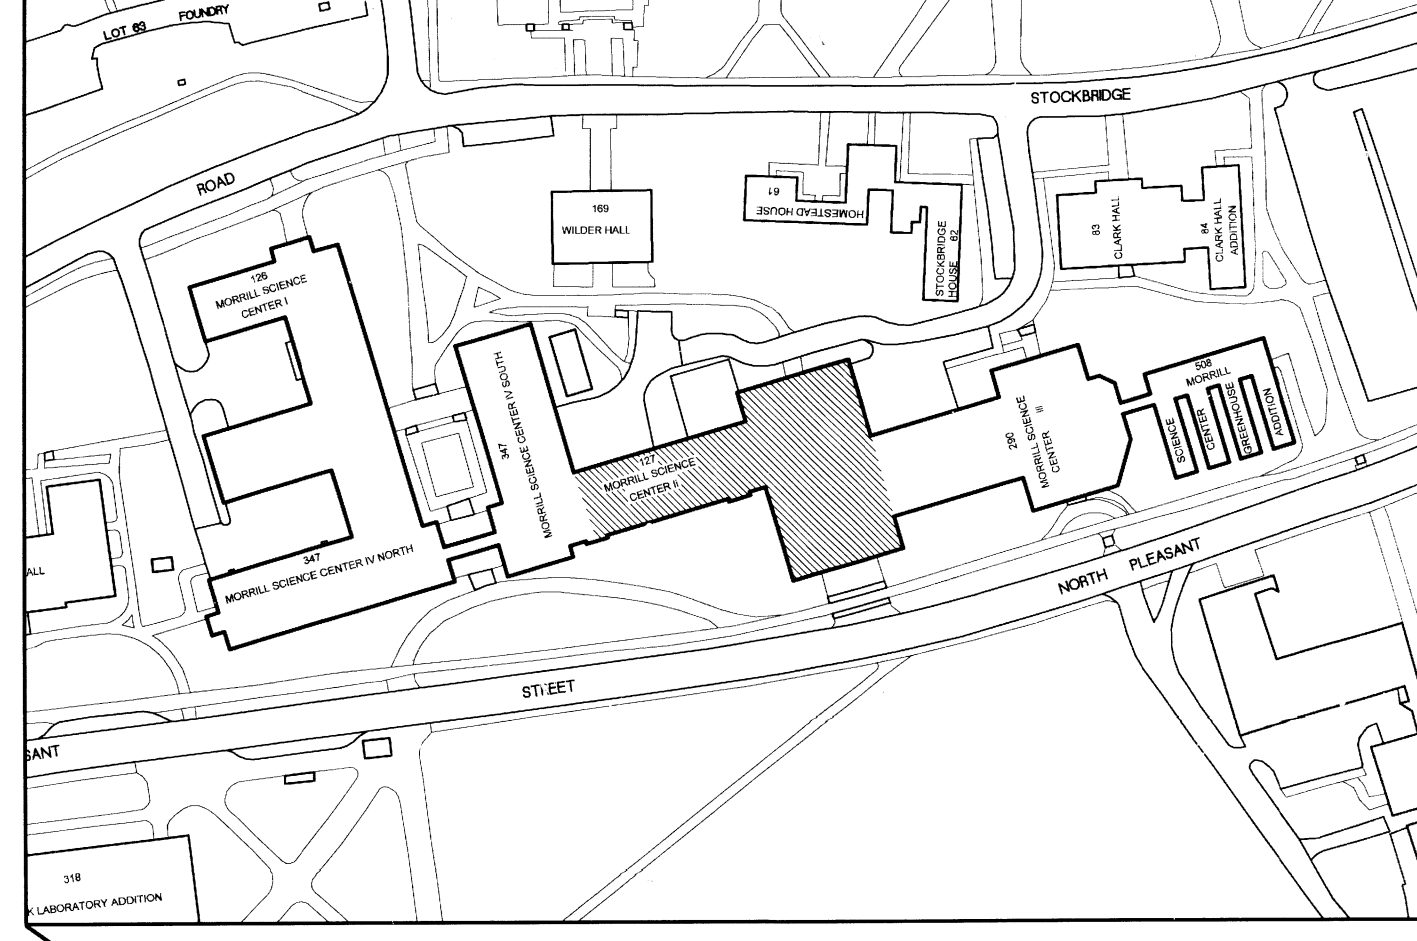

LOCUS PLAN
NOT TO SCALE

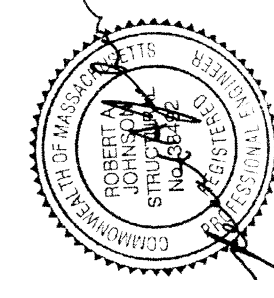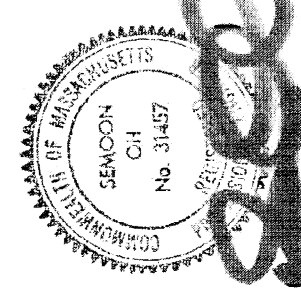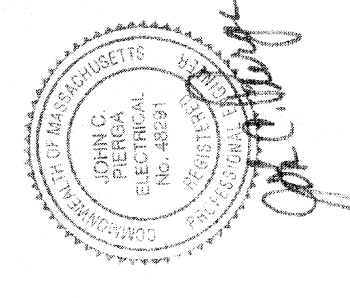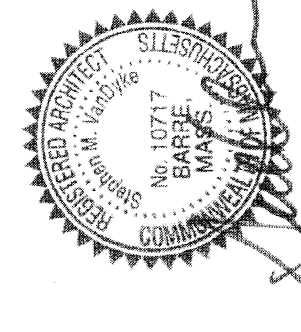

LIST OF DRAWINGS

T101 COVER SHEET

ARCHITECTURAL

- A101 BUILDING PLANS
- A102 BASEMENT AND FIRST FLOOR DEMO & NEW
- A103 THIRD FLOOR DEMO & NEW
- A201 INTERIOR ELEVATIONS
- A301 WALL SECTIONS
- A401 REFLECTED CEILING PLANS
- A501 DETAILS
- A601 DOOR AND FINISH SCHEDULES AND FURNITURE PLAN
- A602 CASEWORK ELEVATIONS
- A603 CASEWORK DETAILS

STRUCTURAL

S1.1 BUILDING PLANS

PLUMBING

- P0.1 PLUMBING SCHEDULES AND LEGEND AND DETAILS
- P0.2 PLUMBING DETAILS
- P0.3 PLUMBING DETAILS
- P1.1 MORRILL II PARTIAL BASEMENT LEVEL PLUMBING PLANS
- P1.2 MORRILL II PARTIAL FIRST FLOOR PLUMBING PLANS
- P1.3 MORRILL II SECOND, THIRD AND FOURTH FLOOR PLUMBING PLANS
- P1.4 MORRILL II PARTIAL, THIRD FLOOR PLUMBING PLAN-DEMOLITION
- P1.5 MORRILL II PARTIAL, THIRD FLOOR PLUMBING PLAN-DEMOLITION
- P1.6 MORRILL II PARTIAL, THIRD FLOOR PLUMBING PLAN-NEW WORK

MECHANICAL

- M.01 HVAC SCHEDULE, DETAILS AND LEGEND
- M1.1 MORRILL II PARTIAL FIRST FLOOR HVAC PLANS
- M1.2 MORRILL II PARTIAL SECOND FLOOR HVAC PLANS
- M1.3 MORRILL II PARTIAL THIRD FLOOR HVAC PLANS
- M2.0 HVAC DETAILS

ELECTRICAL

- E001 ELECTRICAL LEGEND AND NOTES
- E002 ELECTRICAL SCHEDULES AND DETAILS
- E100 ELECTRICAL FLOOR PLANS
- E101 ELECTRICAL FIRST FLOOR NEW WORK PLANS
- E102 ELECTRICAL THIRD FLOOR DEMO PLANS
- E103 ELECTRICAL THIRD FLOOR NEW WORK PLANS

DATE CD SUBMISSION	10.01.10		
DATE CD SUBMISSION	10.28.10		
BID SET	11.19.10		
DESCRIPTION	BY	APPD	DATE
REV. NO.			

 NAULT ARCHITECTS, INC. 71 HOPE AVENUE WORCESTER, MA 01603 TEL: (508) 755-6134 FAX: (508) 755-4661	UNIVERSITY OF MASSACHUSETTS AMHERST MORRILL II ROOMS 336/338 RENOVATIONS COVER SHEET
---	--

BY	DATE	APPD	DATE	WORK ORDER NO.	PROJ-CONTRACT NO.
DRN	AC	10.28.10		09-001759	UMA 11-22
TBD				SCALE	SHEET OF
ENG	IP	10.28.10		AS NOTED	1 OF 32
DWG				DRAWING NUMBER	
PES					D-11-127-09-001759 T101