



Basement Floor - New Fire Protection Plan
SCALE: 1/8" = 1' 0"

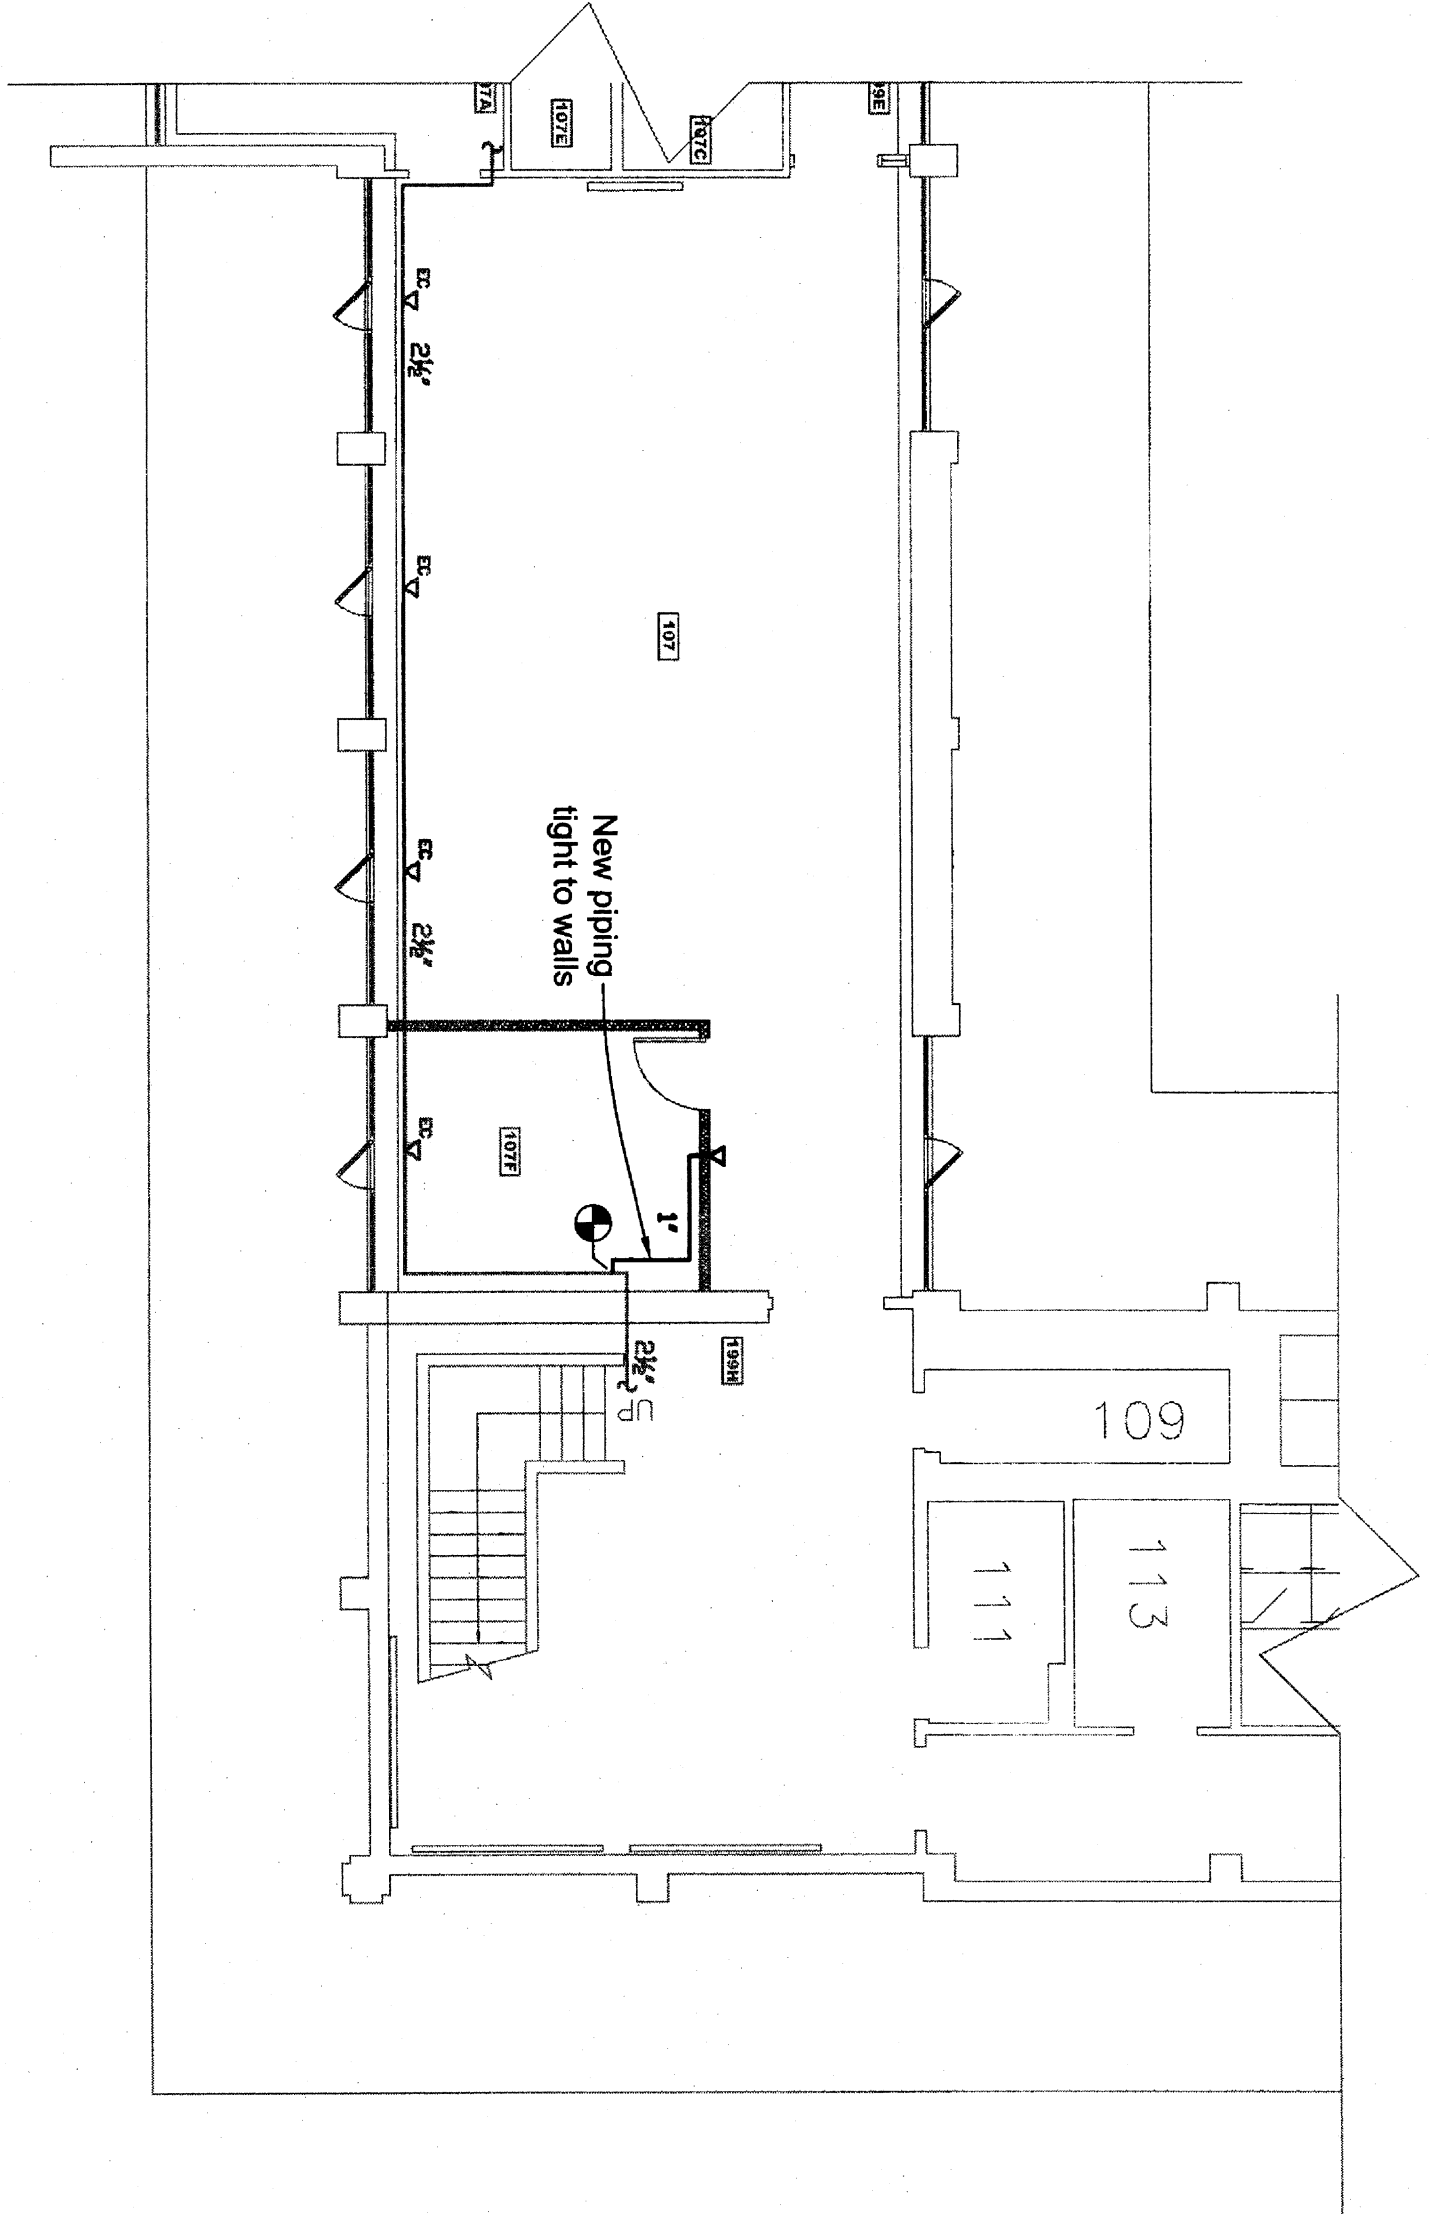


First Floor - New Fire Protection Plan
SCALE: 1/8" = 1' 0"

SPRINKLER HEAD LEGEND									
SYMBOL	COUNT	TYPE	METAL TEMP.	K	NPT ORIF.	MAKE	MODEL #	LOCATION	
▲	38	Side	White	155	4.0 1/2"	1/2"	Viking	VK453R	Exposed
▽	1	Side	White	155	5.6 1/2"	1/2"	Viking	VK408	Concealed

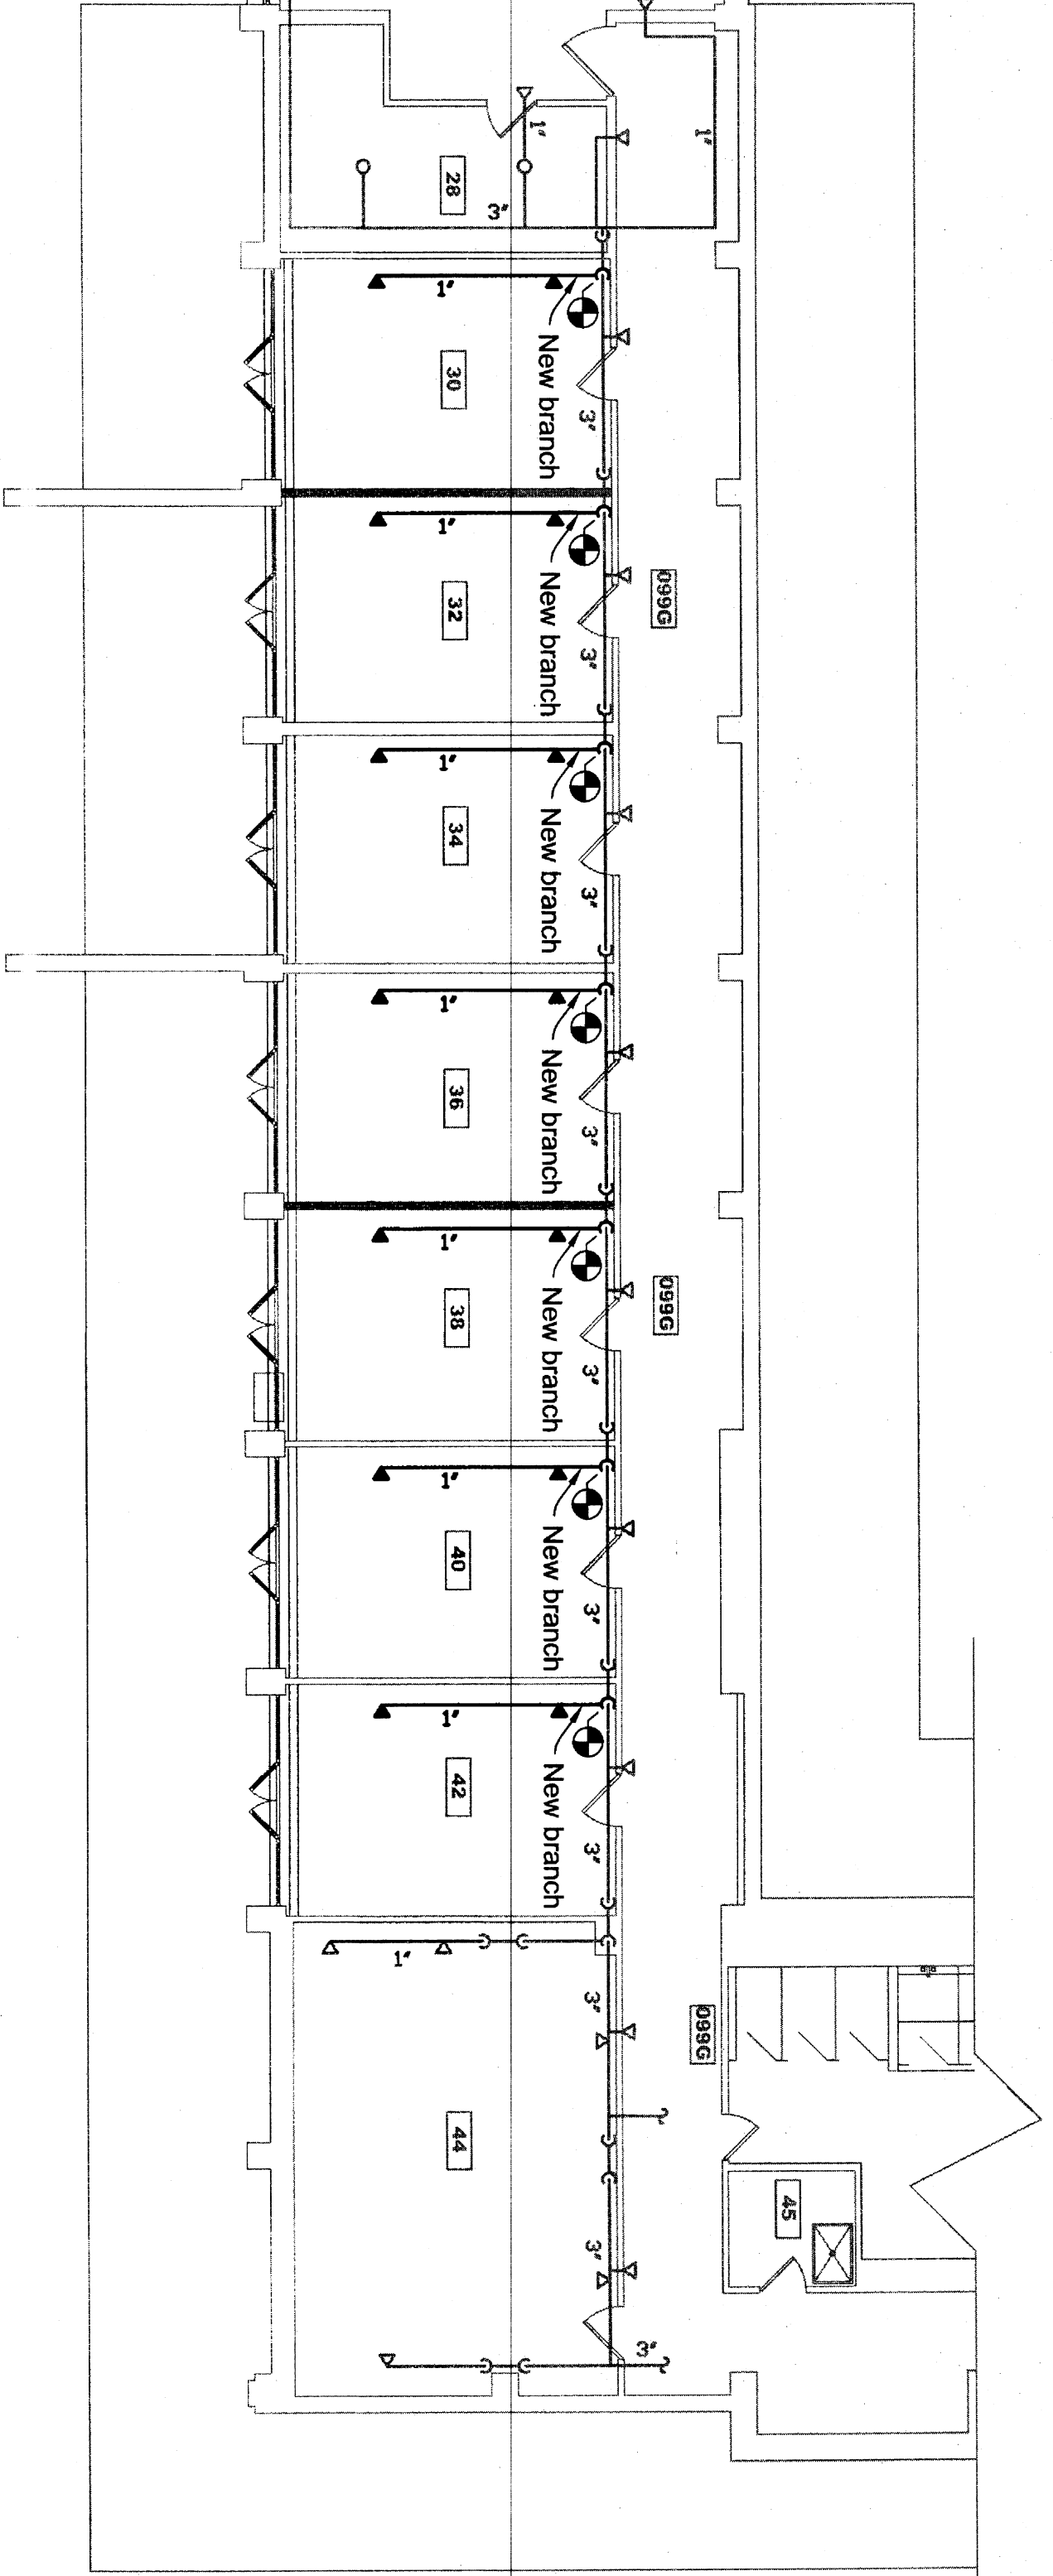

Pierpont House - Bldg. #401
201 Fearing Street, Amherst, Ma. 01003-9215
Basement Student Rooms
NEW FIRE PROTECTION PLAN

UNIVERSITY OF MASSACHUSETTS
FACILITIES PLANNING
AMHERST, MASSACHUSETTS

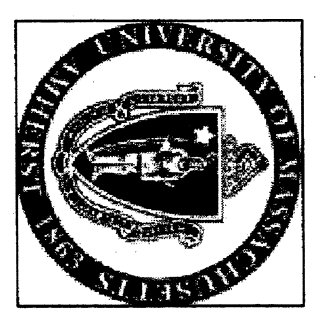


PROJECT NO.: 10-00176201

CONTRACT NO.: UMA # 11-33

NO.	DESCRIPTION	DATE

DRAWN BY: RFG
CHECKED BY: RFG
DESIGNED BY: RFG
SCALE: 1/8" = 1'-0"
DATE: 02/02/2011

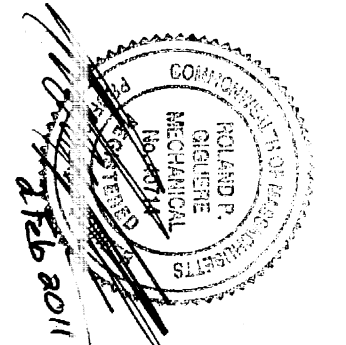

DRAWING NO.
A-401-10-00176201
FP-2