



DRAWING NOTES


- 1 REMOVE EXISTING WATER COOLER AND ALL ASSOCIATED PIPING, REFRIGERATION AND CAP ALL EXISTING CW WASTE AND REPAIR ANY CRACKS IN THE WALL THAT IS ASSOCIATED WITH WATER COOLER.
- 2 NEW PF-4 WILL REQUIRE 1/2" CW, 1 1/2" WASTE & 1 1/2" VENT CONNECTIONS. PLUMBING SUB-CONTRACTOR SHALL VERIFY IN FIELD EXISTING CONDITIONS AND LOCATION OF NEW PF-4 AND COORDINATE FINAL LOCATION WITH ARCHITECT.
- 3 PLUMBING SUB-CONTRACTOR SHALL VERIFY IN FIELD EXISTING SIZES AND LOCATIONS OF EXISTING PLUMBING PIPING WITHIN PLUMBING CHASE BEING USED FOR NEW CONNECTIONS FROM PF-4.

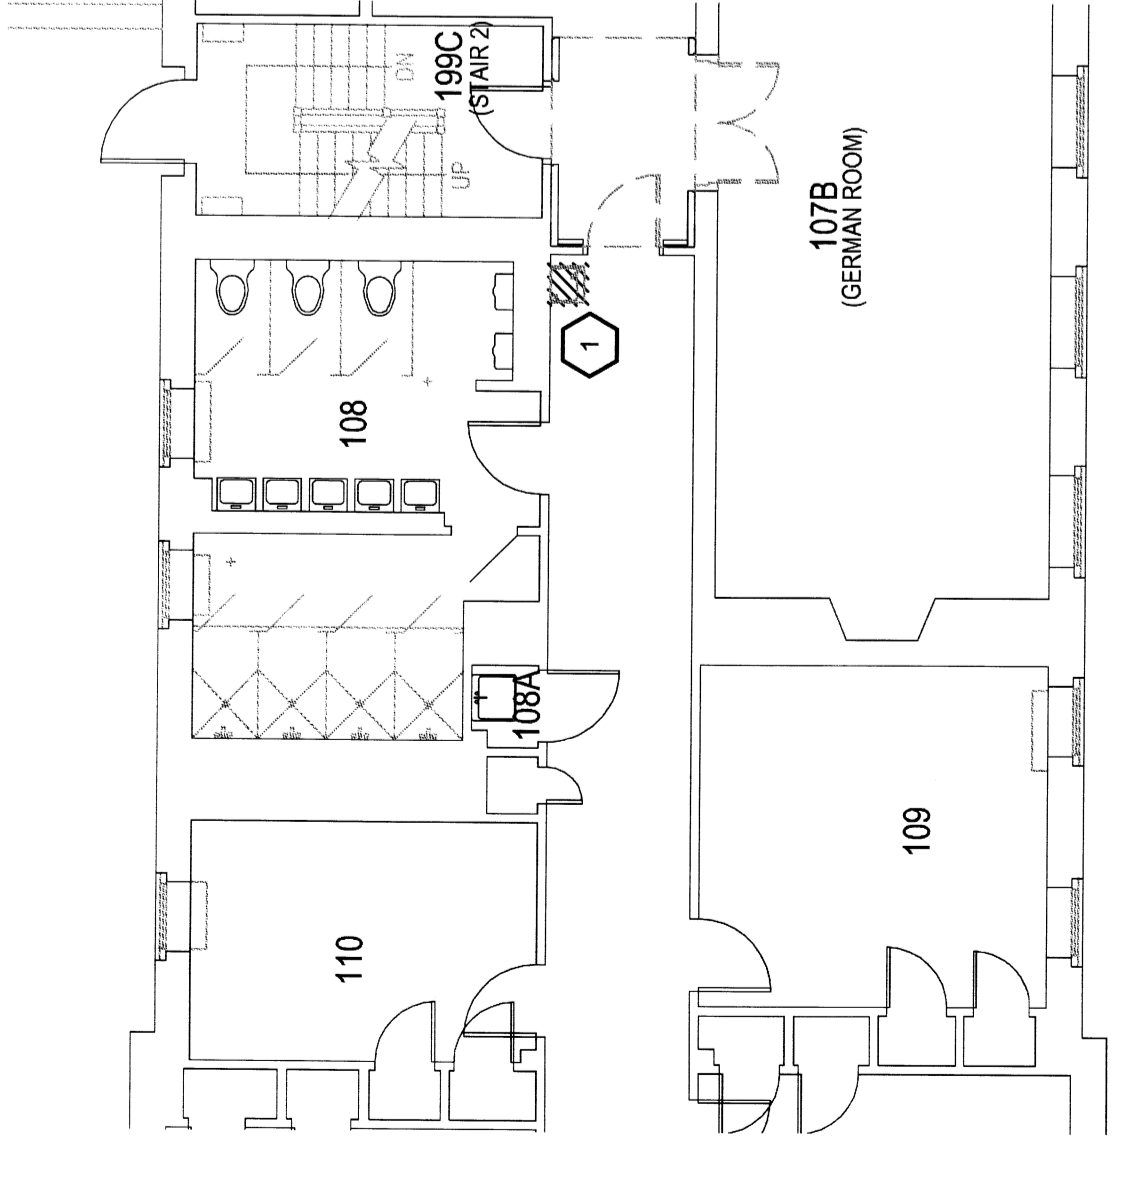


FIRST FLOOR PLUMBING DEMOLITION PLAN
1/8"=1'-0"

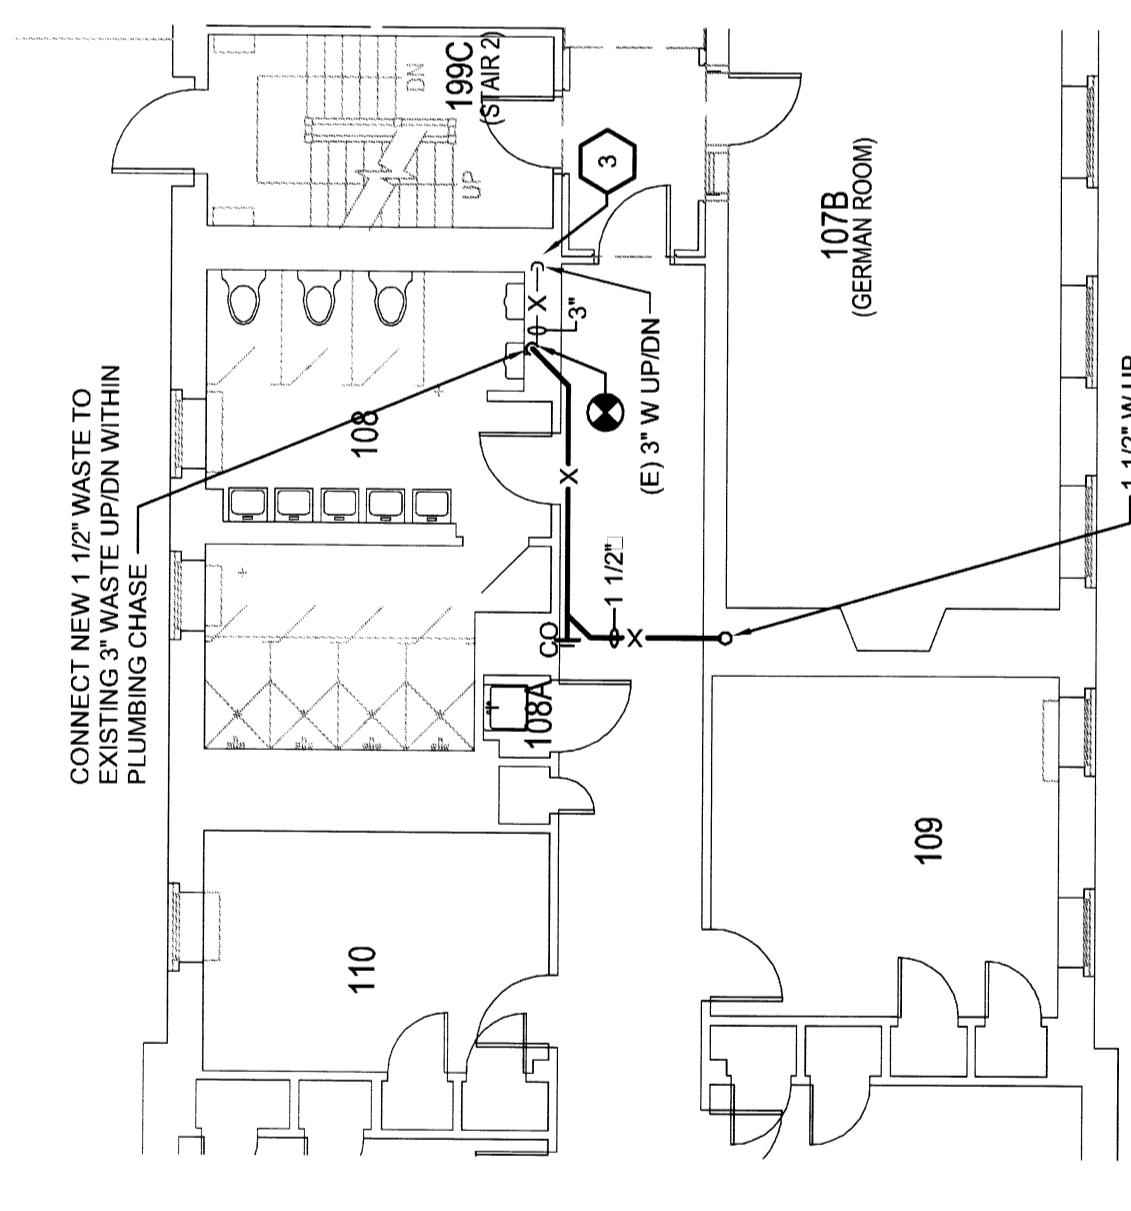


FIRST FLOOR PLUMBING PLAN
1/8"=1'-0"

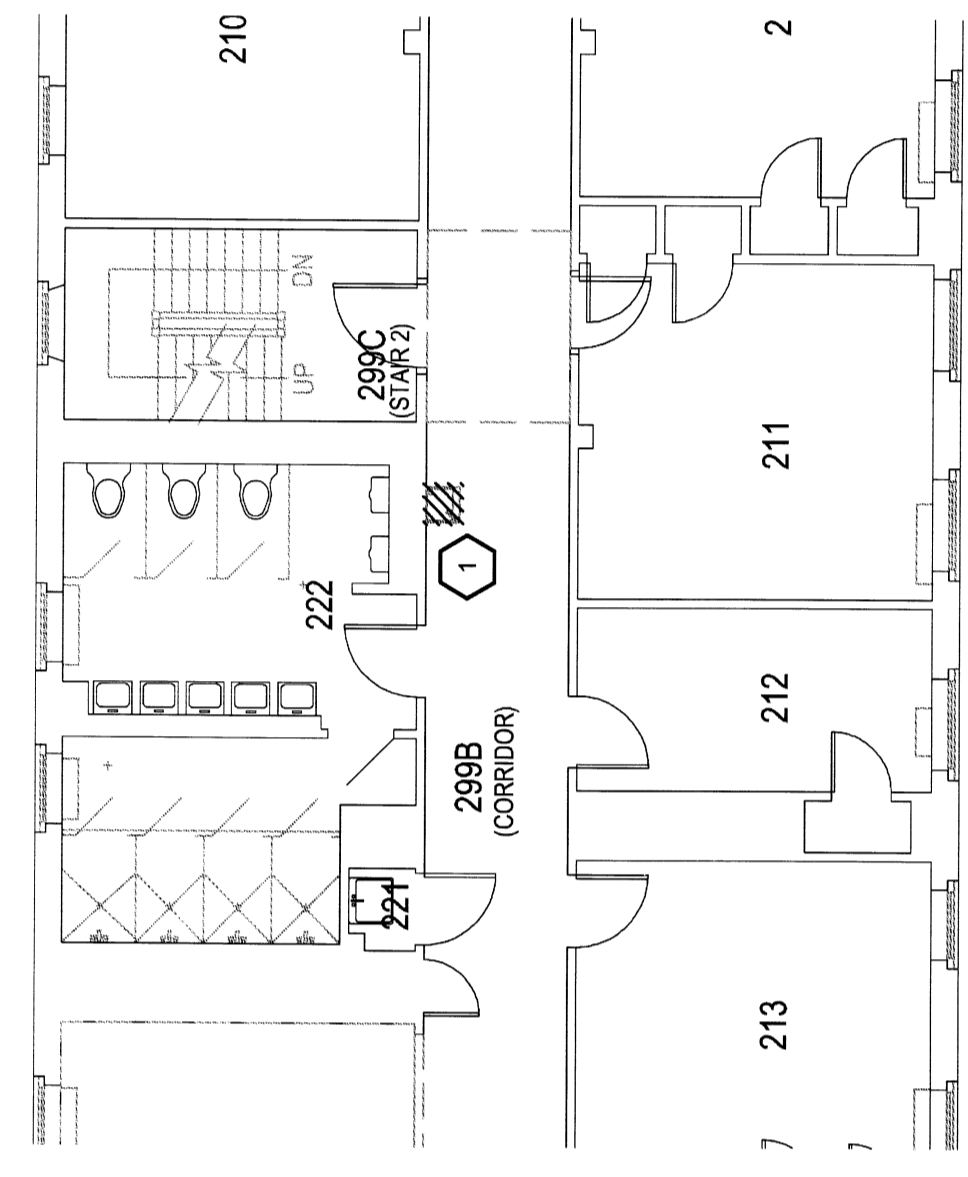


SECOND FLOOR PLUMBING DEMOLITION PLAN
1/8"=1'-0"

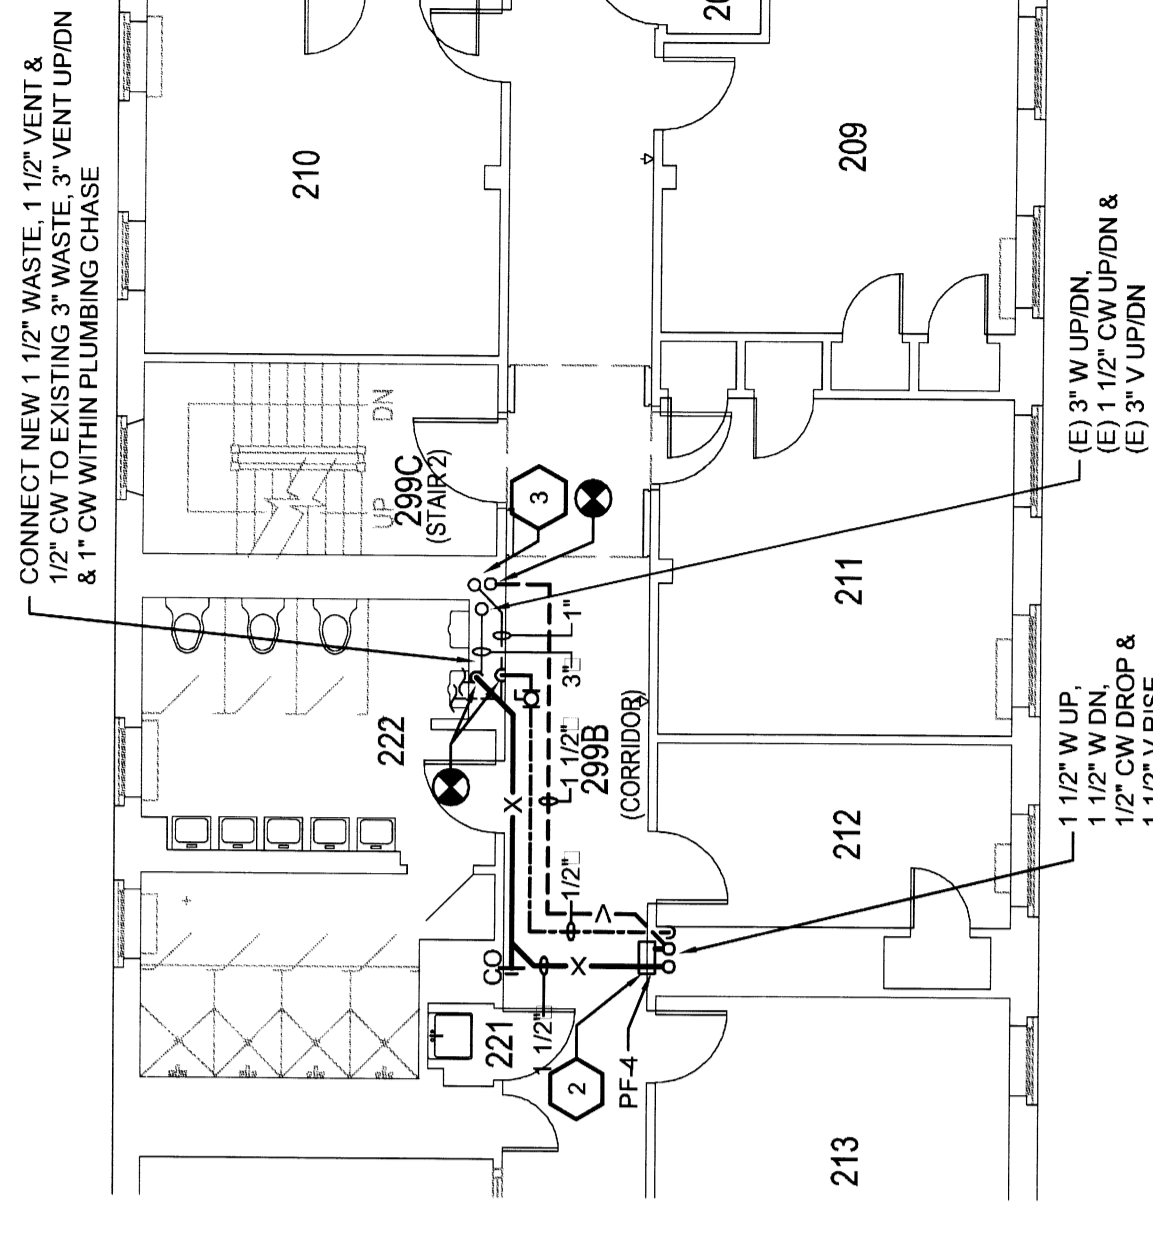


SECOND FLOOR PLUMBING PLAN
1/8"=1'-0"

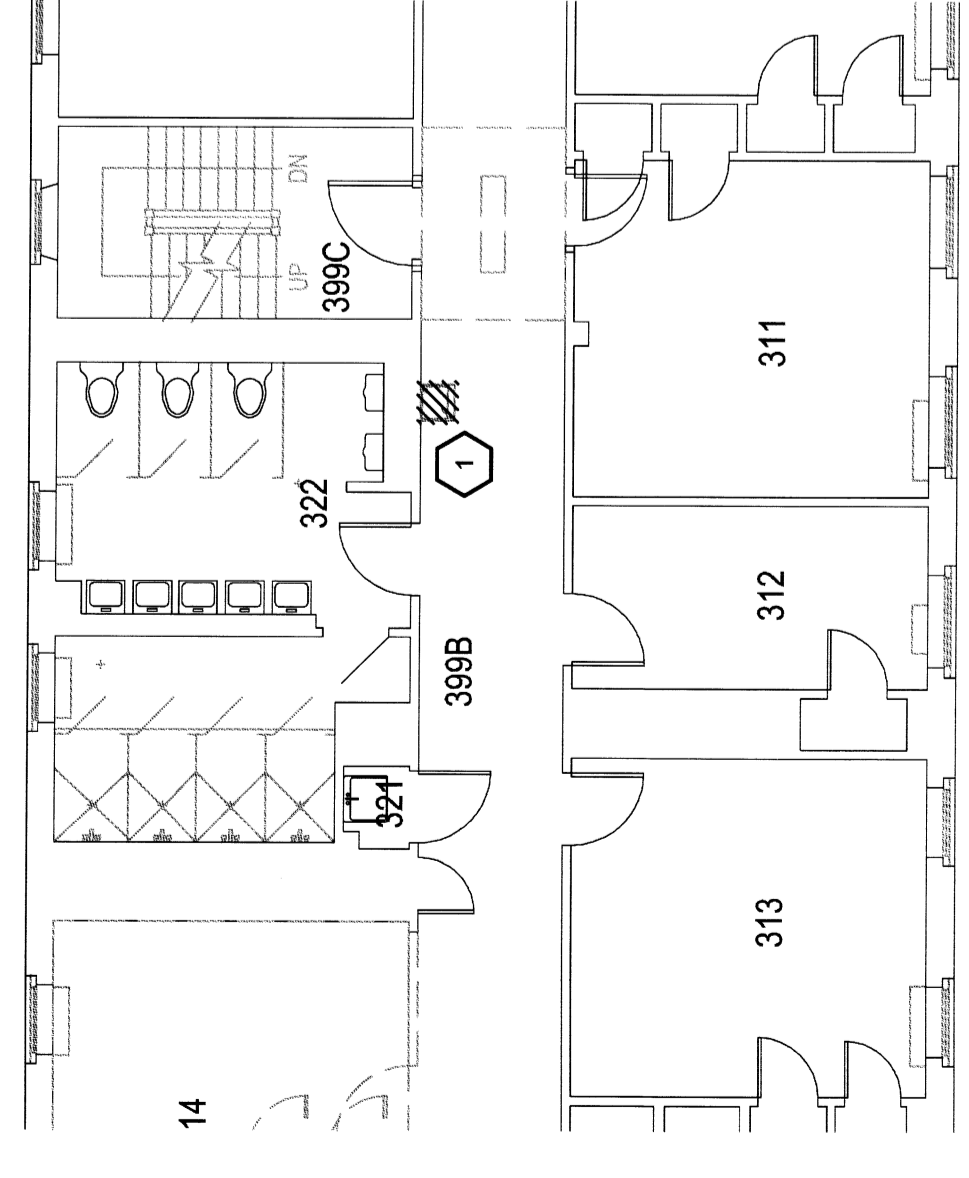


THIRD FLOOR PLUMBING DEMOLITION PLAN
1/8"=1'-0"

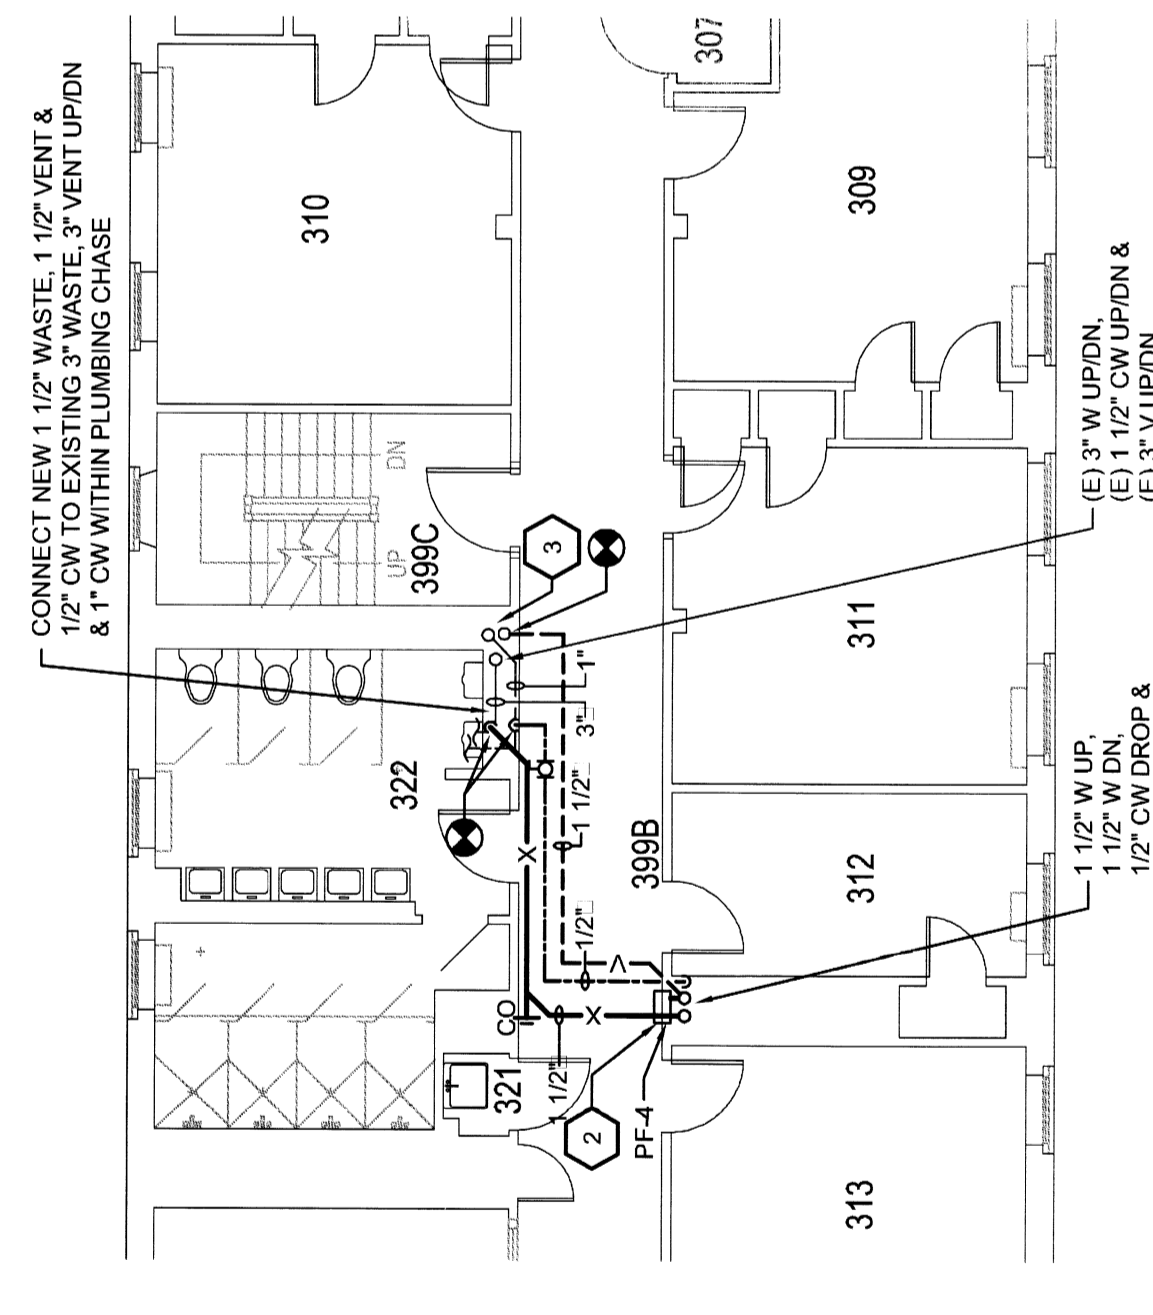

THIRD FLOOR PLUMBING PLAN
1/8"=1'-0"

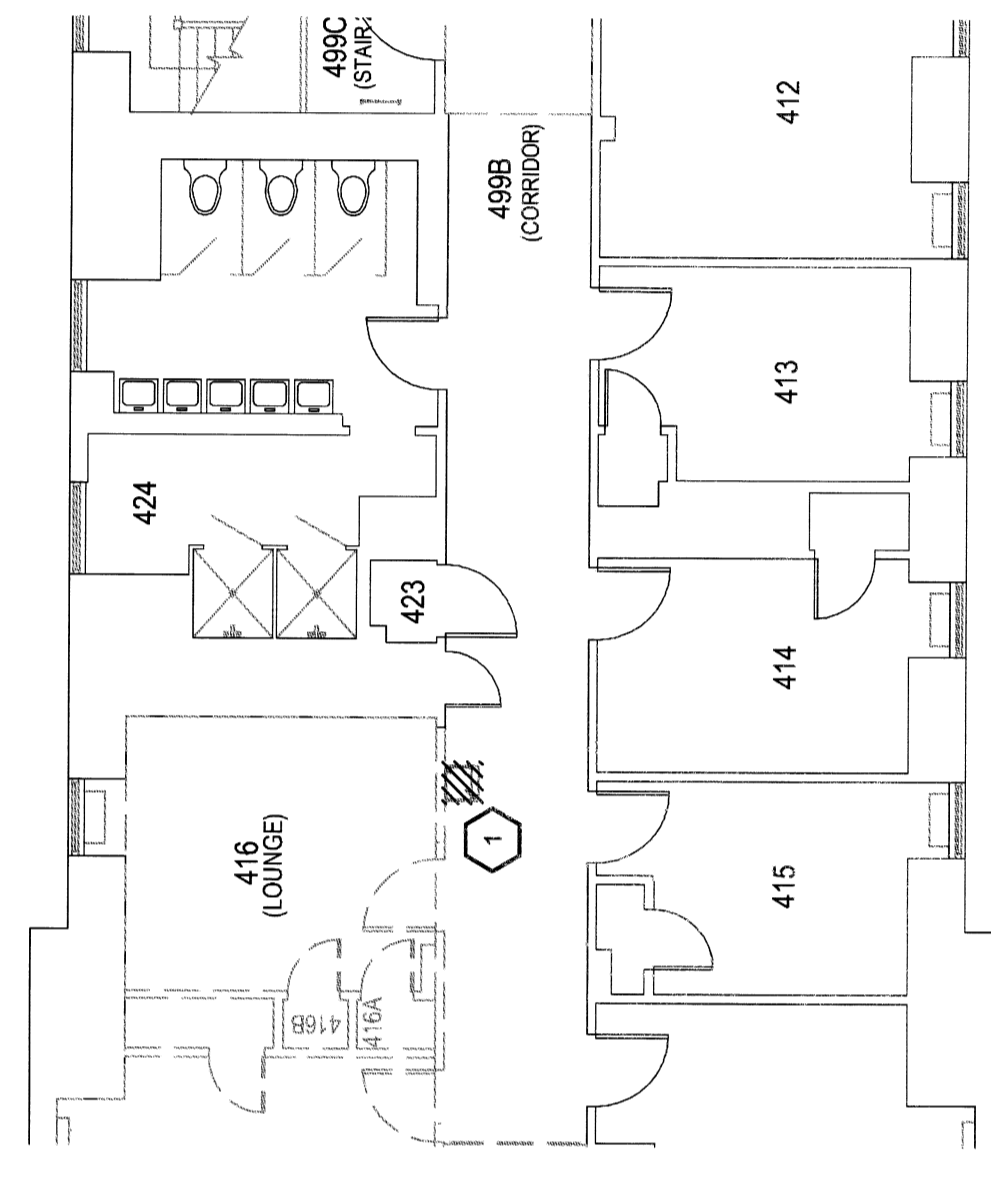

FOURTH FLOOR PLUMBING DEMOLITION PLAN
1/8"=1'-0"

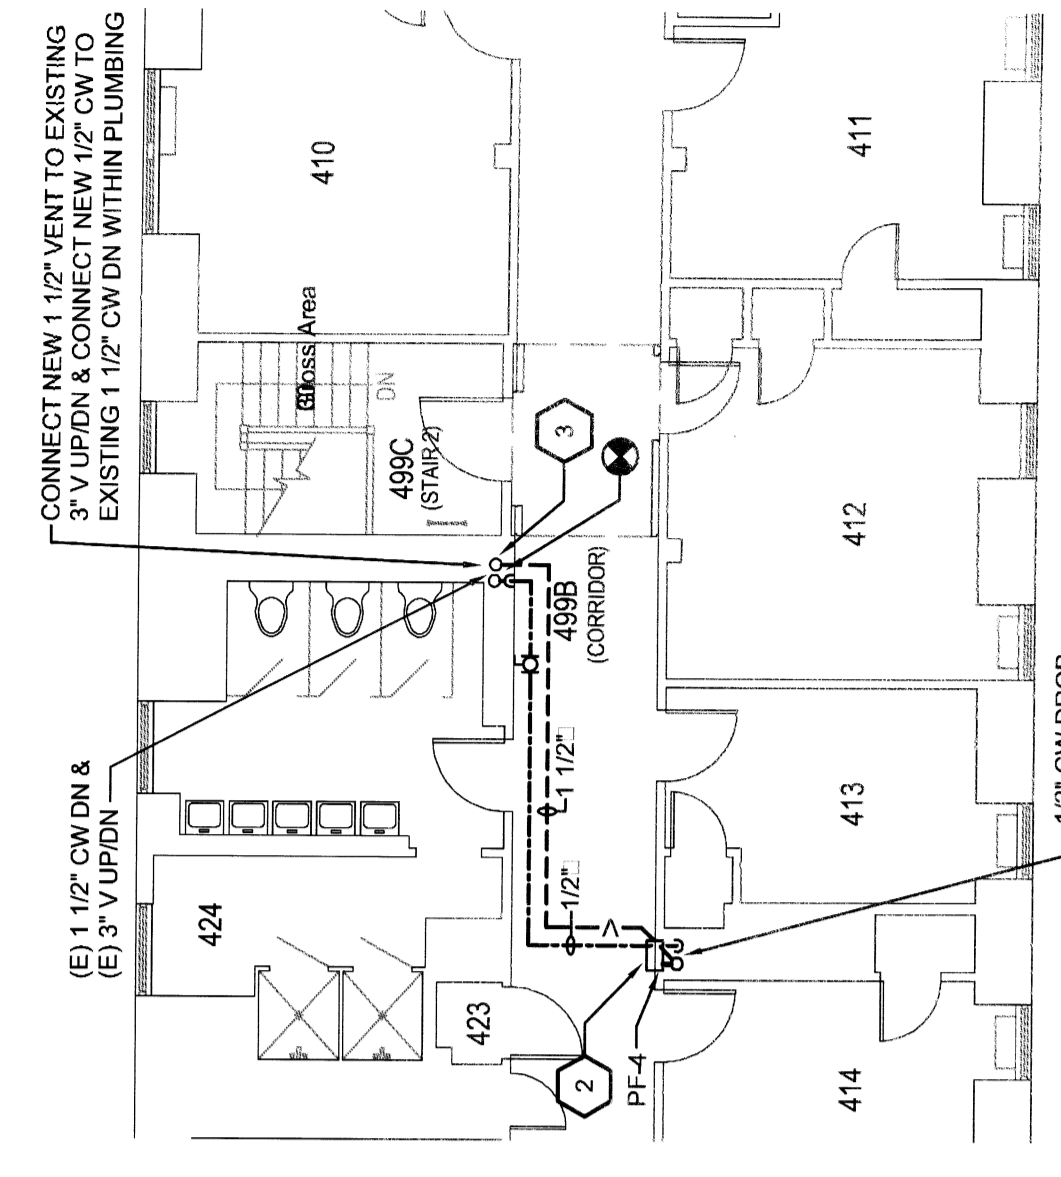

FOURTH FLOOR PLUMBING PLAN
1/8"=1'-0"

REV. NO.	DESCRIPTION	BY	APPD	DATE

UNIVERSITY OF MASSACHUSETTS
FACILITIES PLANNING DIVISION

LEWIS HALL & THATCHER HALL
FINISH UPGRADE 2011

BY	DATE	PROJECT NO.	CONTRACT NO.
DRN	AUG	100278001	UMA 10-010
APPD	SBS	SCALE	SHEET
		1/8" = 1'-0"	
CAD		DRAWING NUMBER	
APPD		THATCHER	PT2.1

PLAN NORTH

0 5 10 15 20 FT

RFS *engineering*

Red Free Shumney Engineering, P.C.
175 Main Street
Lancaster, MA 02046
P: 603.524.4647
F: 603.528.7653
www.rfsengineering.com

THIS DOCUMENT IS UNCLASSIFIED BY THE ARCHITECT AND IS NOT TO BE REPRODUCED OR TRANSMITTED IN ANY FORM OR BY ANY MEANS, ELECTRONIC OR MECHANICAL, INCLUDING PHOTOCOPYING, RECORDING, OR BY ANY INFORMATION STORAGE AND RETRIEVAL SYSTEM, WITHOUT THE WRITTEN PERMISSION OF THE ARCHITECT. THE ARCHITECT'S LIABILITY IS LIMITED TO THE PROFESSIONAL SERVICES PROVIDED HEREIN.