


Morrill IV, Bldg. #347

Lab Renovation, RM 434, 434A, 438, 38A, 438B


627 North Pleasant Street, Amherst, Ma. 01003 UMA #11-52

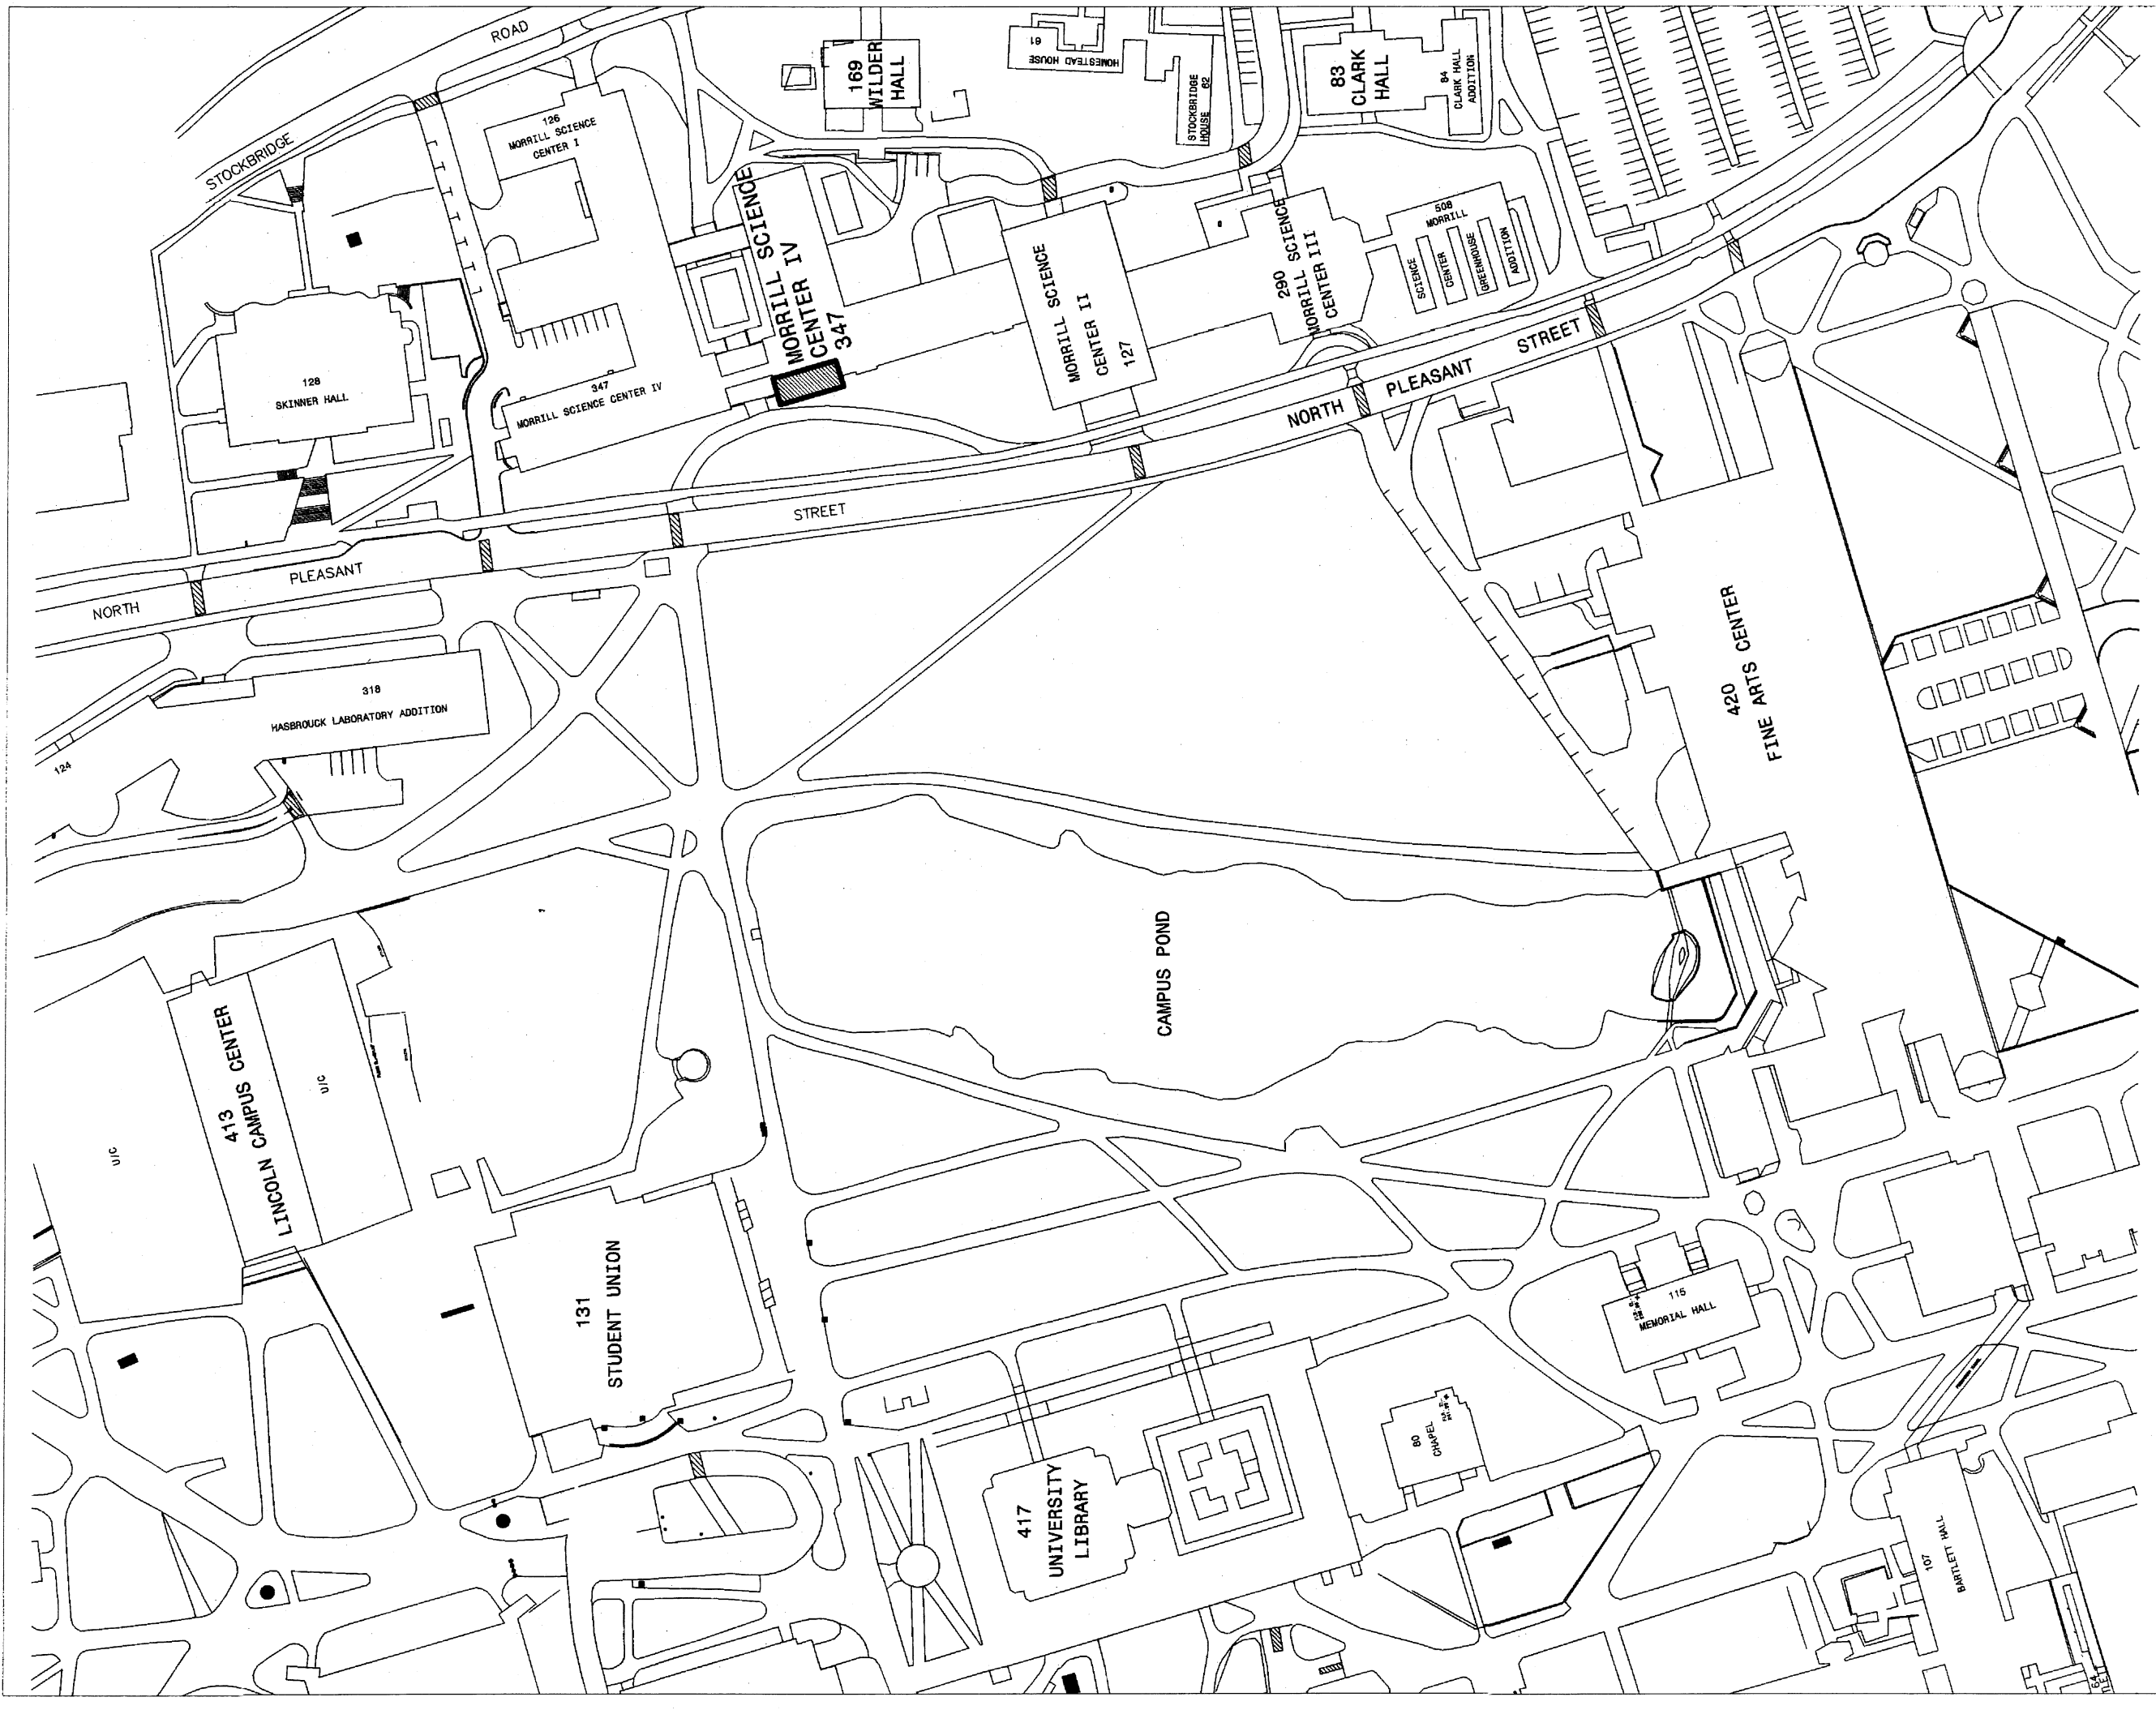

CAMPUS LOCUS PLAN

SCALE: Not to Scale

BUILDING LOCATION

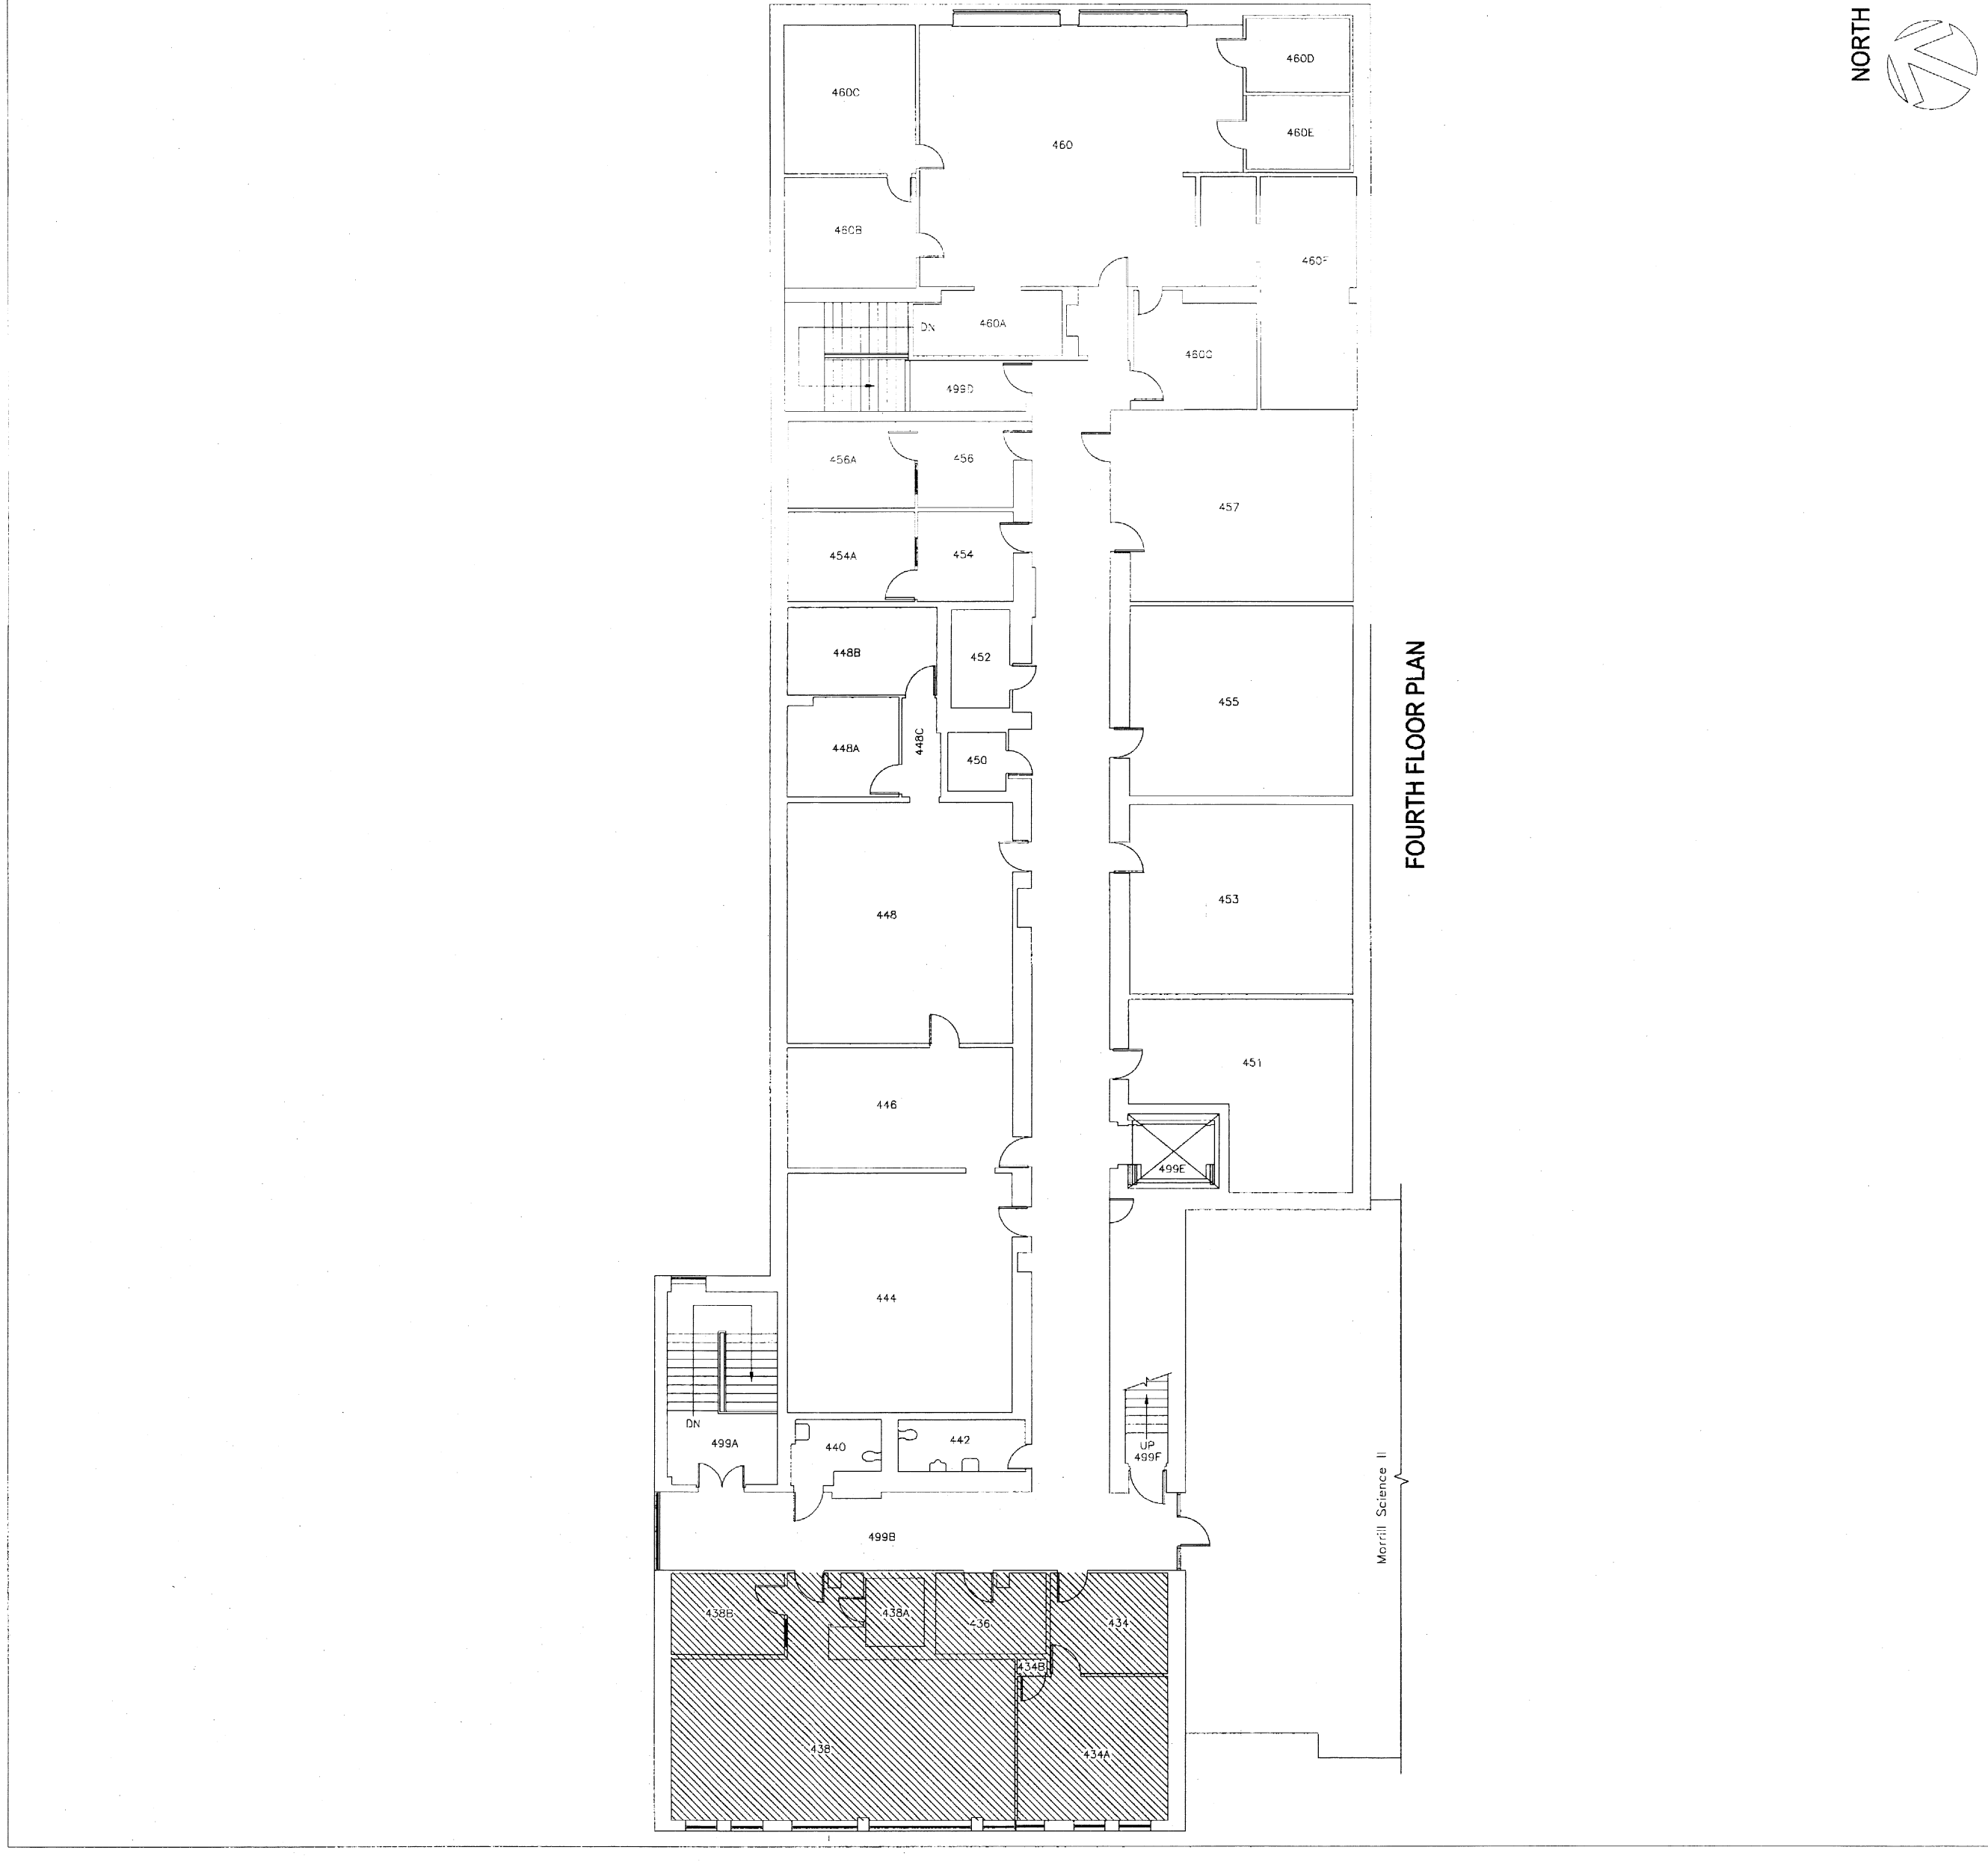

BUILDING LOCUS PLAN

SCALE: Not to Scale

WORK AREA

LIST OF DRAWINGS

T-0	TITLE SHEET
A-1	DEMOLITION PLAN
A-2	NEW FLOOR PLAN
A-3	NEW EQUIPMENT LOCATION PLAN
A-4	INTERIORS ELEVATIONS
A-5	NEW REFLECTED CEILING PLAN
A-6	ROOM FINISH SCHEDULE, WALL TYPES AND DETAILS
A-7	DOOR / FRAME SCHEDULE, TYPES AND DETAILS
P-1	PLUMBING DEMOLITION PLAN
P-2	PROPOSED PLUMBING PLAN
H-1	HVAC PLANS
H-2	HVAC DETAILS AND SCHEDULES
E-1	ELECTRICAL SYMBOLS AND DEMOLITION PLAN
E-2	LIGHTING AND POWER PLAN
E-3	FIRE ALARM PLAN

UNIVERSITY OF MASSACHUSETTS
FACILITIES PLANNING
AMHERST, MASSACHUSETTS

FACILITIES PLANNING
UNIVERSITY OF MASSACHUSETTS
AMHERST, MA 01003
VOICE: 413.545.3363
FAX: 413.545.3384

Morrill IV, Bldg. # 347
Lab Renovation 434, 434A, 438, 438A & 438B
627 North Pleasant Street, Amherst, Ma. 01003
TITLE SHEET

PROJECT NO.: 09-00176001
CONTRACT NO.: UMA # 11-52

DATE	06/15/2011
SCALE	As Shown
DESIGNED BY	J.M.
CHECKED BY	T.J.R.
DRAWN BY	T.J.R.

DRAWING NO.
A-347-09-00176001

T-0

PROJECT ARCHITECT

PROJECT ELEC. ENGINEER

PROJECT HVAC ENGINEER

PROJECT PLUM. ENGINEER