




VAULT #1 PIPE SCHEMATIC PLAN
N.T.S.

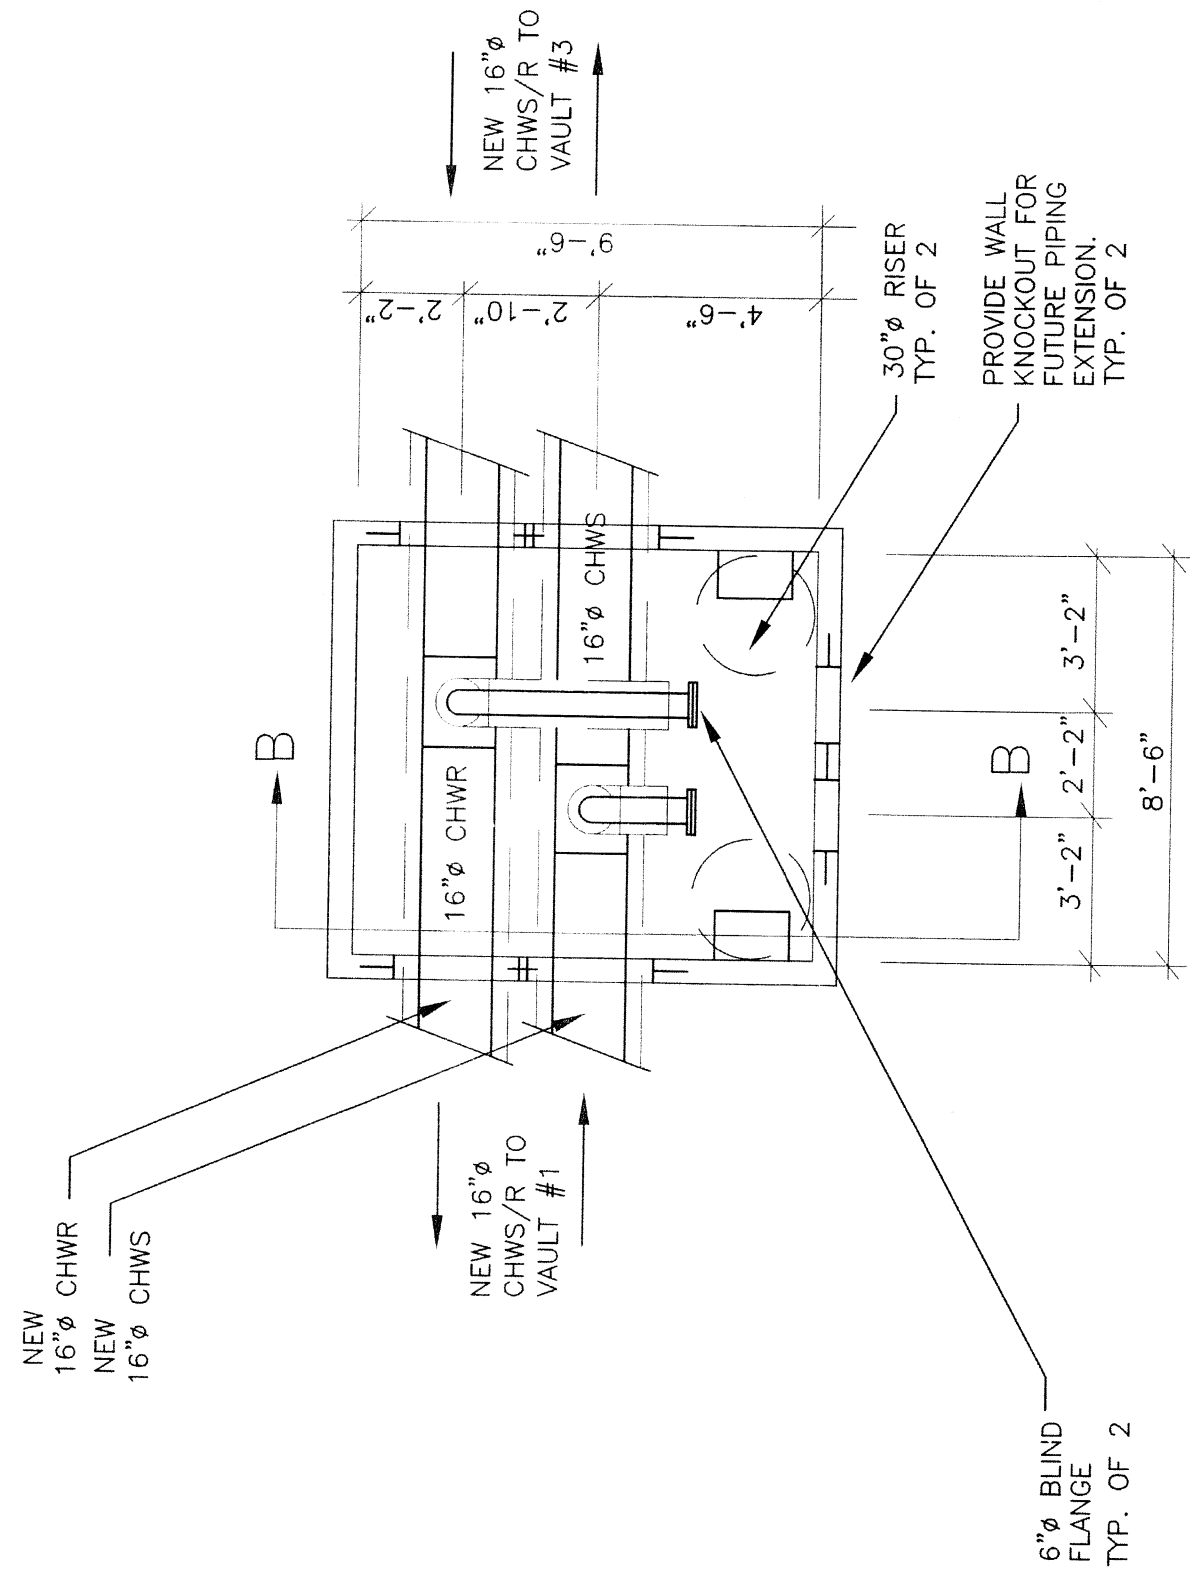


VAULT #2 PIPE SCHEMATIC PLAN
N.T.S.

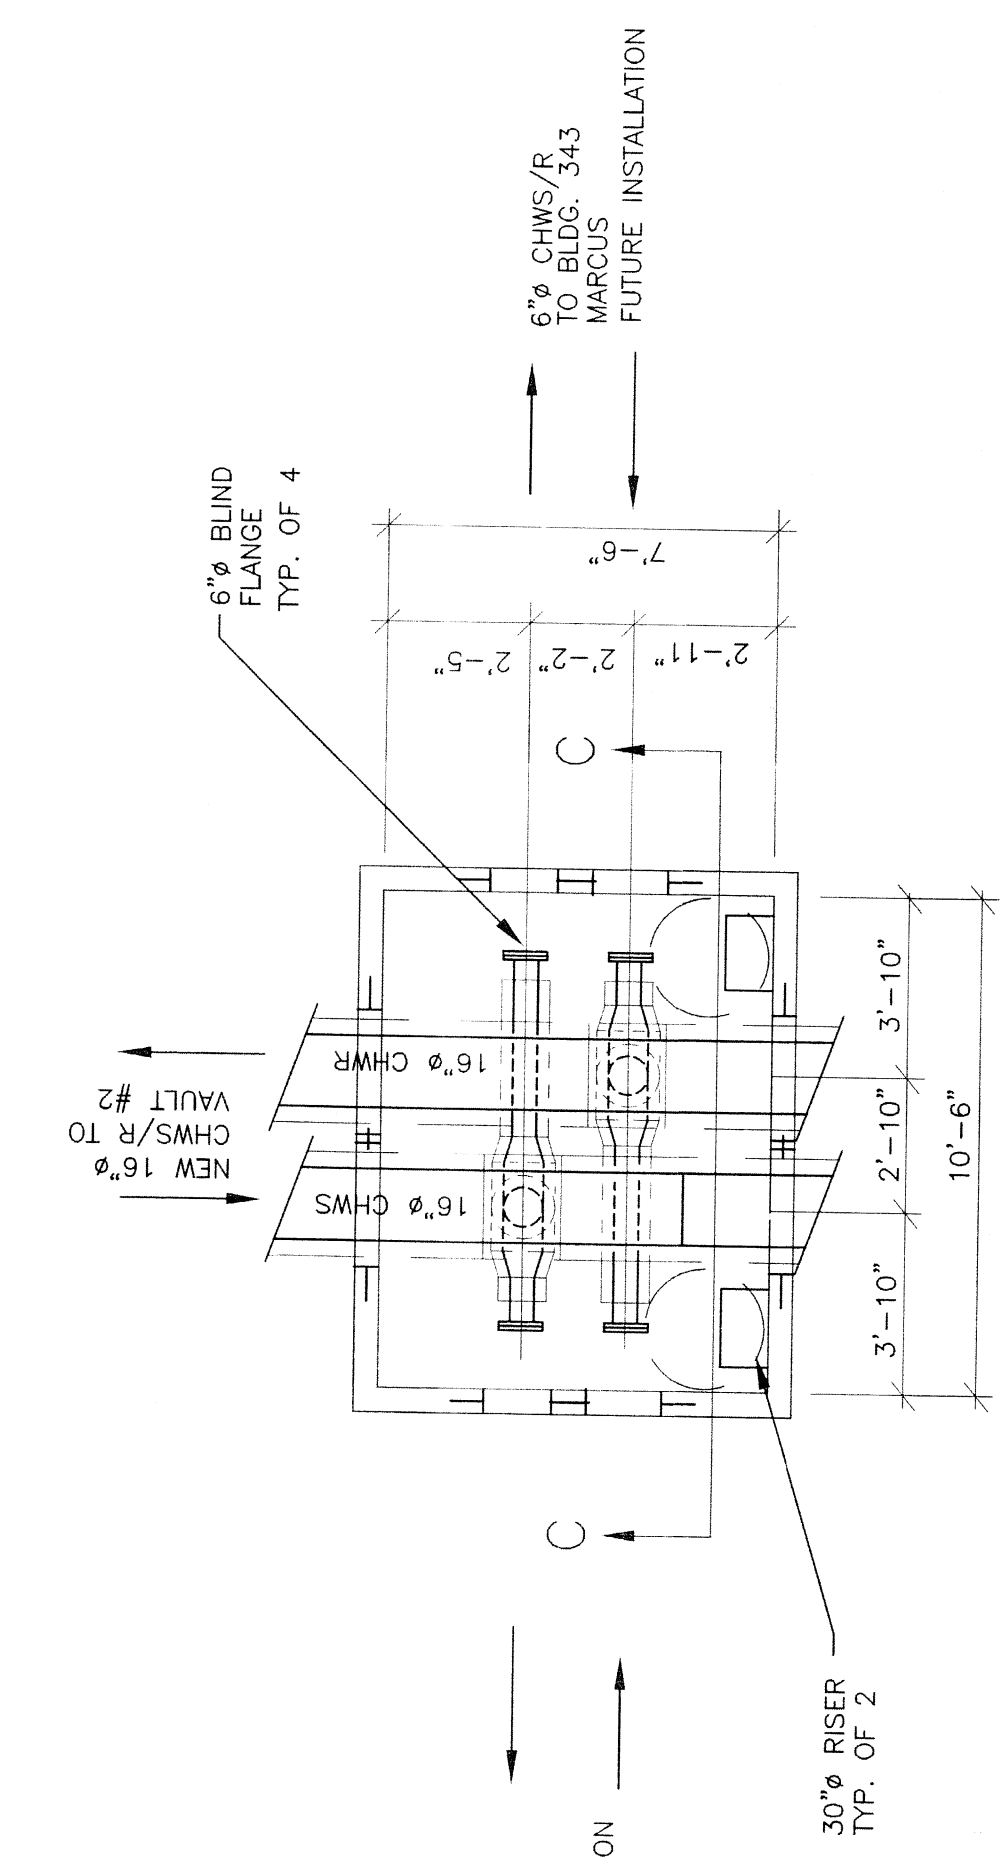


VAULT #3 PIPE SCHEMATIC PLAN
N.T.S.

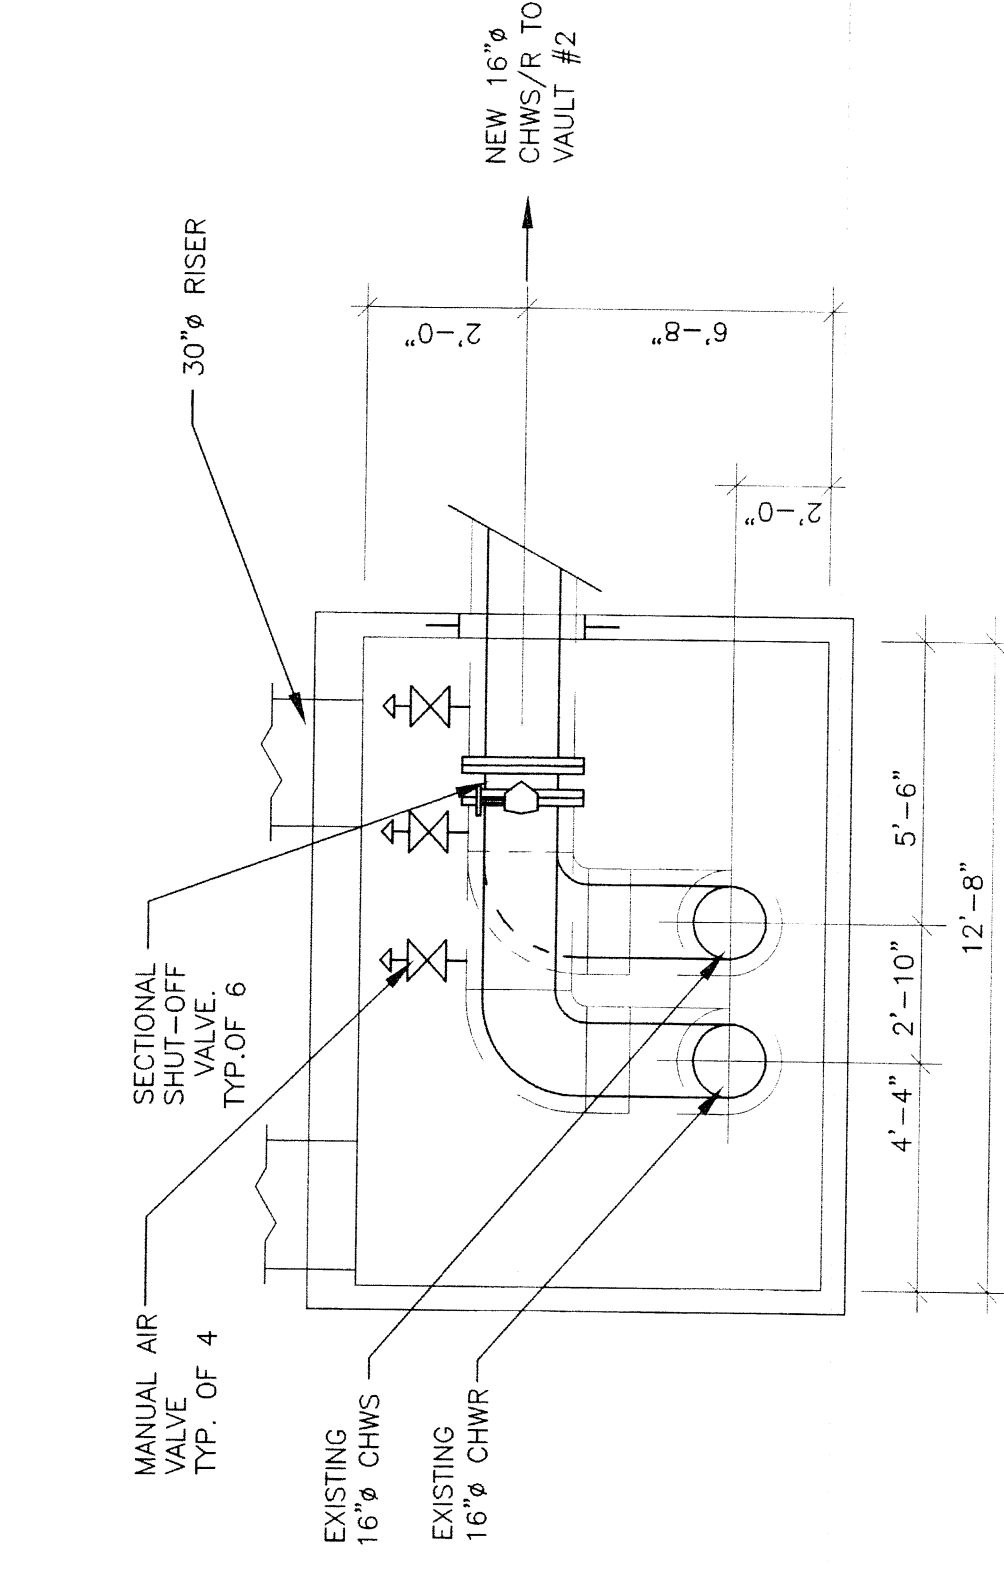


VAULT #1 SECTION A-A
N.T.S.

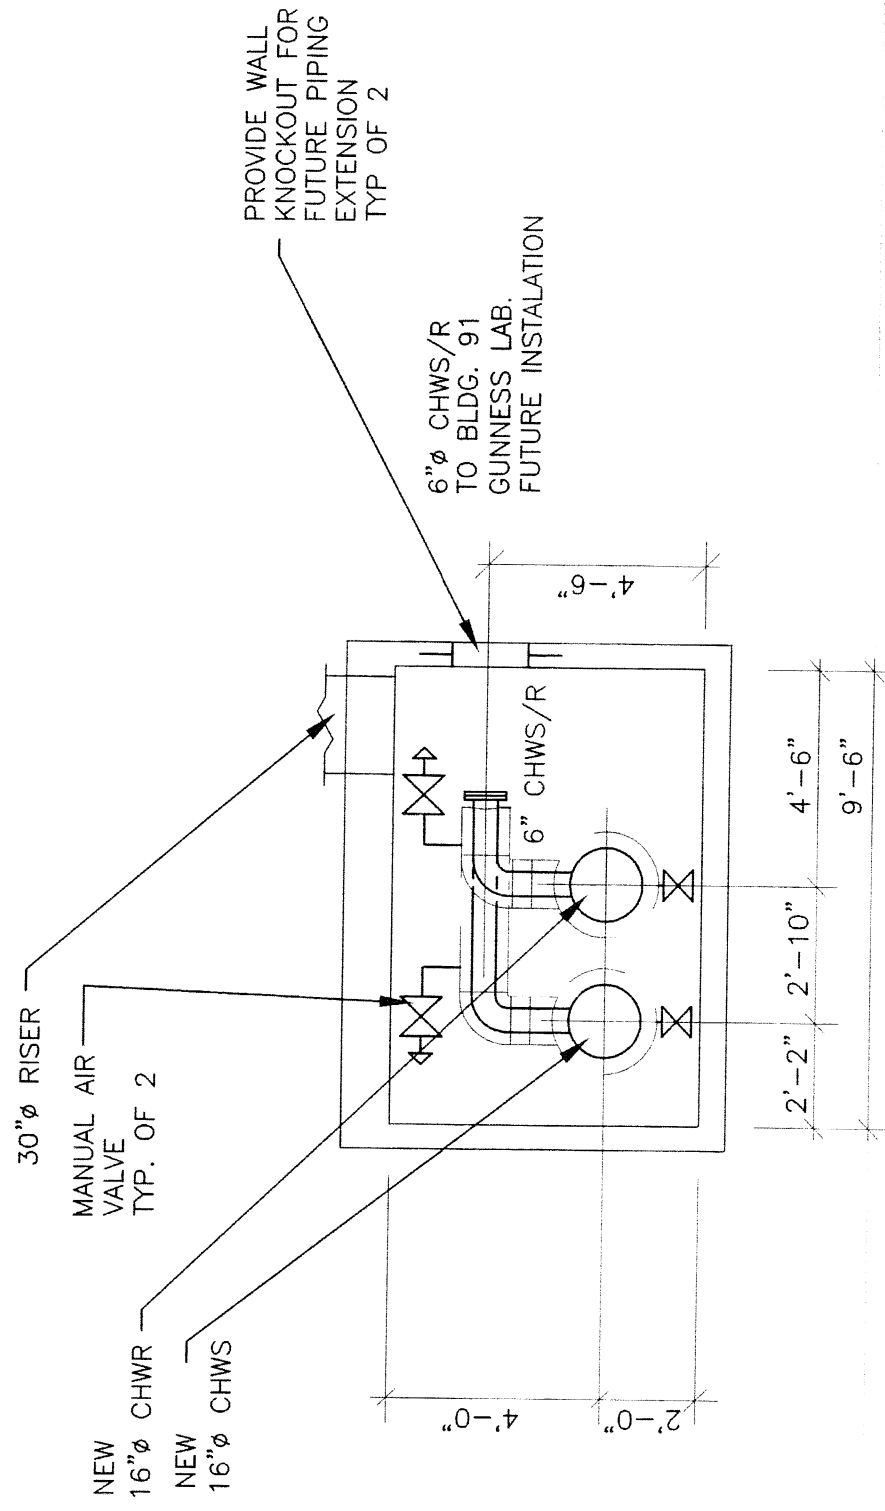

VAULT #2 SECTION B-B
N.T.S.

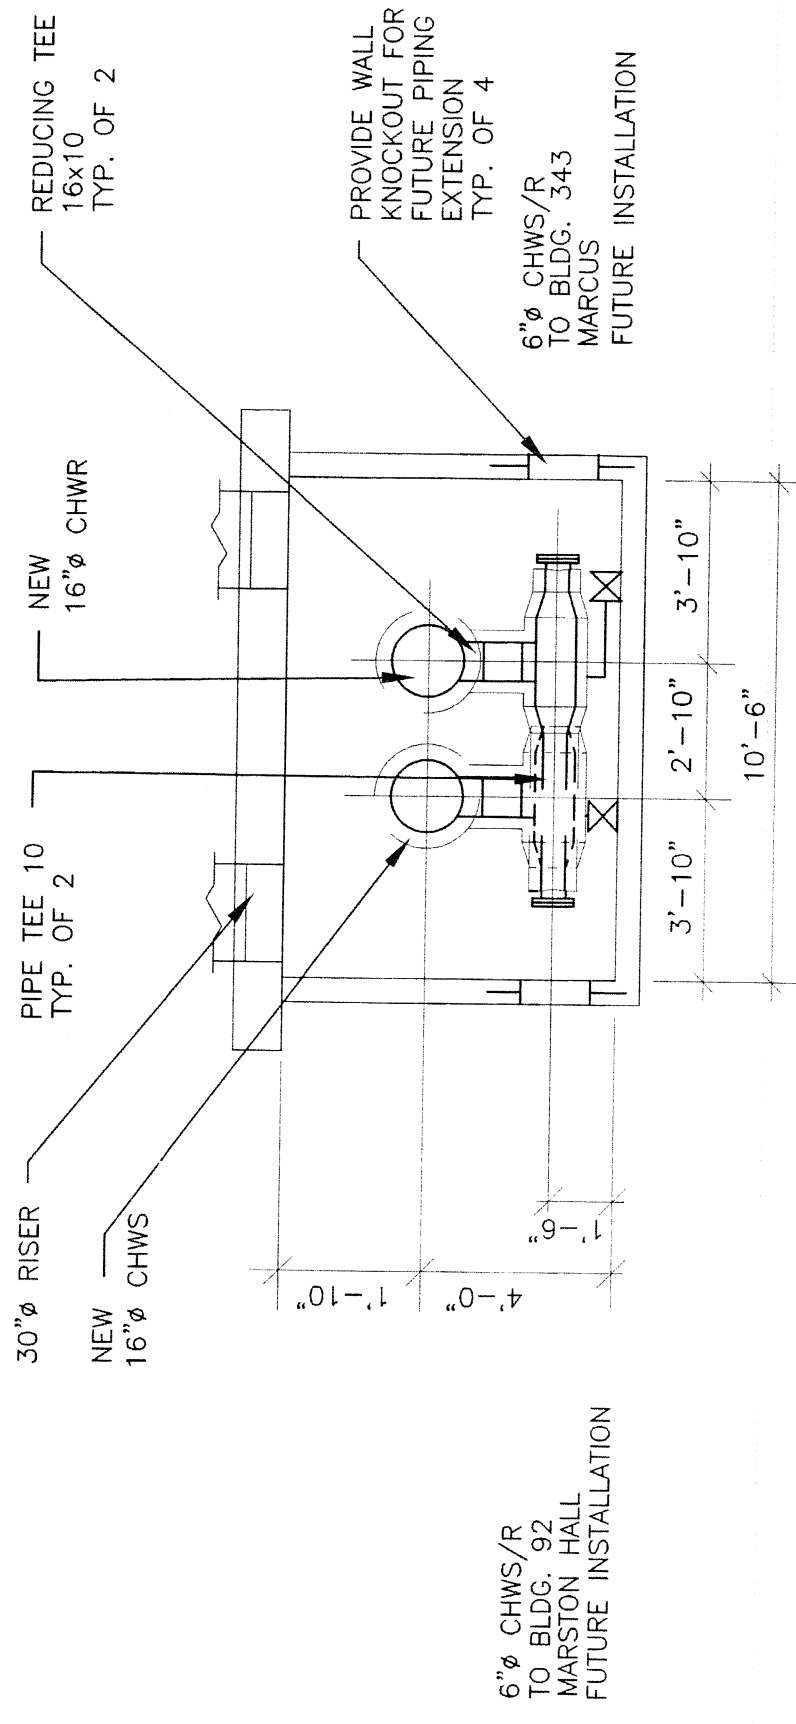


VAULT #3 SECTION C-C
N.T.S.

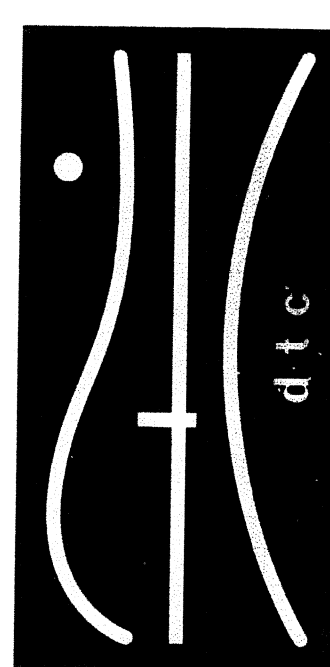

DIVERSIFIED TECHNOLOGY CONSULTANTS
257 WEST STREET, SUITE 200, LOWELL, MA 01854
978.452.1234
305 N. MAIN STREET, SUITE 202 ANDOVER, MA 01810
978.452.1234

NO. 1		DATE 12/21/11	BY	APP'D. DATE
NO. 2		DATE	BY	APP'D. DATE
NO. 3		DATE	BY	APP'D. DATE
NO. 4		DATE	BY	APP'D. DATE
NO. 5		DATE	BY	APP'D. DATE
NO. 6		DATE	BY	APP'D. DATE
NO. 7		DATE	BY	APP'D. DATE
NO. 8		DATE	BY	APP'D. DATE
NO. 9		DATE	BY	APP'D. DATE
NO. 10		DATE	BY	APP'D. DATE

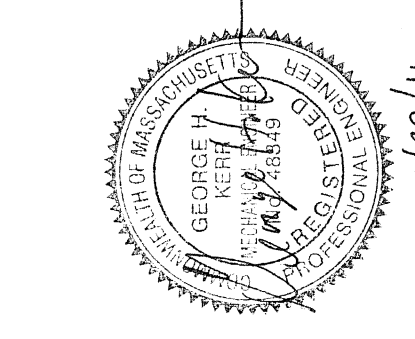

UNIVERSITY OF MASSACHUSETTS
FACILITIES PLANNING DIVISION
UTILITIES, NORTHWEST
CHILLED WATER LOOP PHASE I
MECHANICAL DETAILS

DRILL DATE PROJECT NO. CONTRACT NO. TMA.1530
APP'D. DATE SCALE AS NOTED SHEET 14 OF 30
CHK. DATE 12/21/11 DRAWING NUMBER
APP'D. DATE 12/21/11