



TectonArchitects inc

HARTFORD CONNECTICUT
860 548 0802
tectonarchitects.com

Notice:
This drawing is the property of Tecton Architects | inc. The use, re-use or reproduction of this drawing for any purpose whatsoever without an expressed written agreement between Tecton Architects | inc and the user is prohibited. Rights to use the information on this sheet are not transferred until payment has been received for services rendered. Any rights so granted are non-transferable to other parties without the prior expressed written consent of Tecton Architects | inc

© 2010 Tecton Architects | inc



GARCIA-GALUSKA-DESOUZA
CONSULTING ENGINEERS
INC.
370 Faunce Corner Road, Dartmouth, MA 02747-1271
508-998-0700 • FAX 508-998-0883 • E-MAIL info@g-g-d.com


Owner
TOWN OF WILBRAHAM

240 SPRINGFIELD STREET
WILBRAHAM, MA

Project
Wilbraham Fire Station

2770 Boston Road
Wilbraham, MA

Key Plan

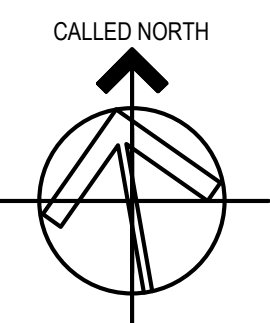

Seals
BID SET

Issues	Date	Description

Revisions	No.	Date	Description

Drawing Title
**ROOF PLAN
PLUMBING**

Issue Date: 01/19/12


Project No: TA-01-01 Scale: 1/8" = 1'-0"

Project Manager: JM Production Leader:

Project Architect: JB Peer Reviewer:

Drawing Number

P2.101

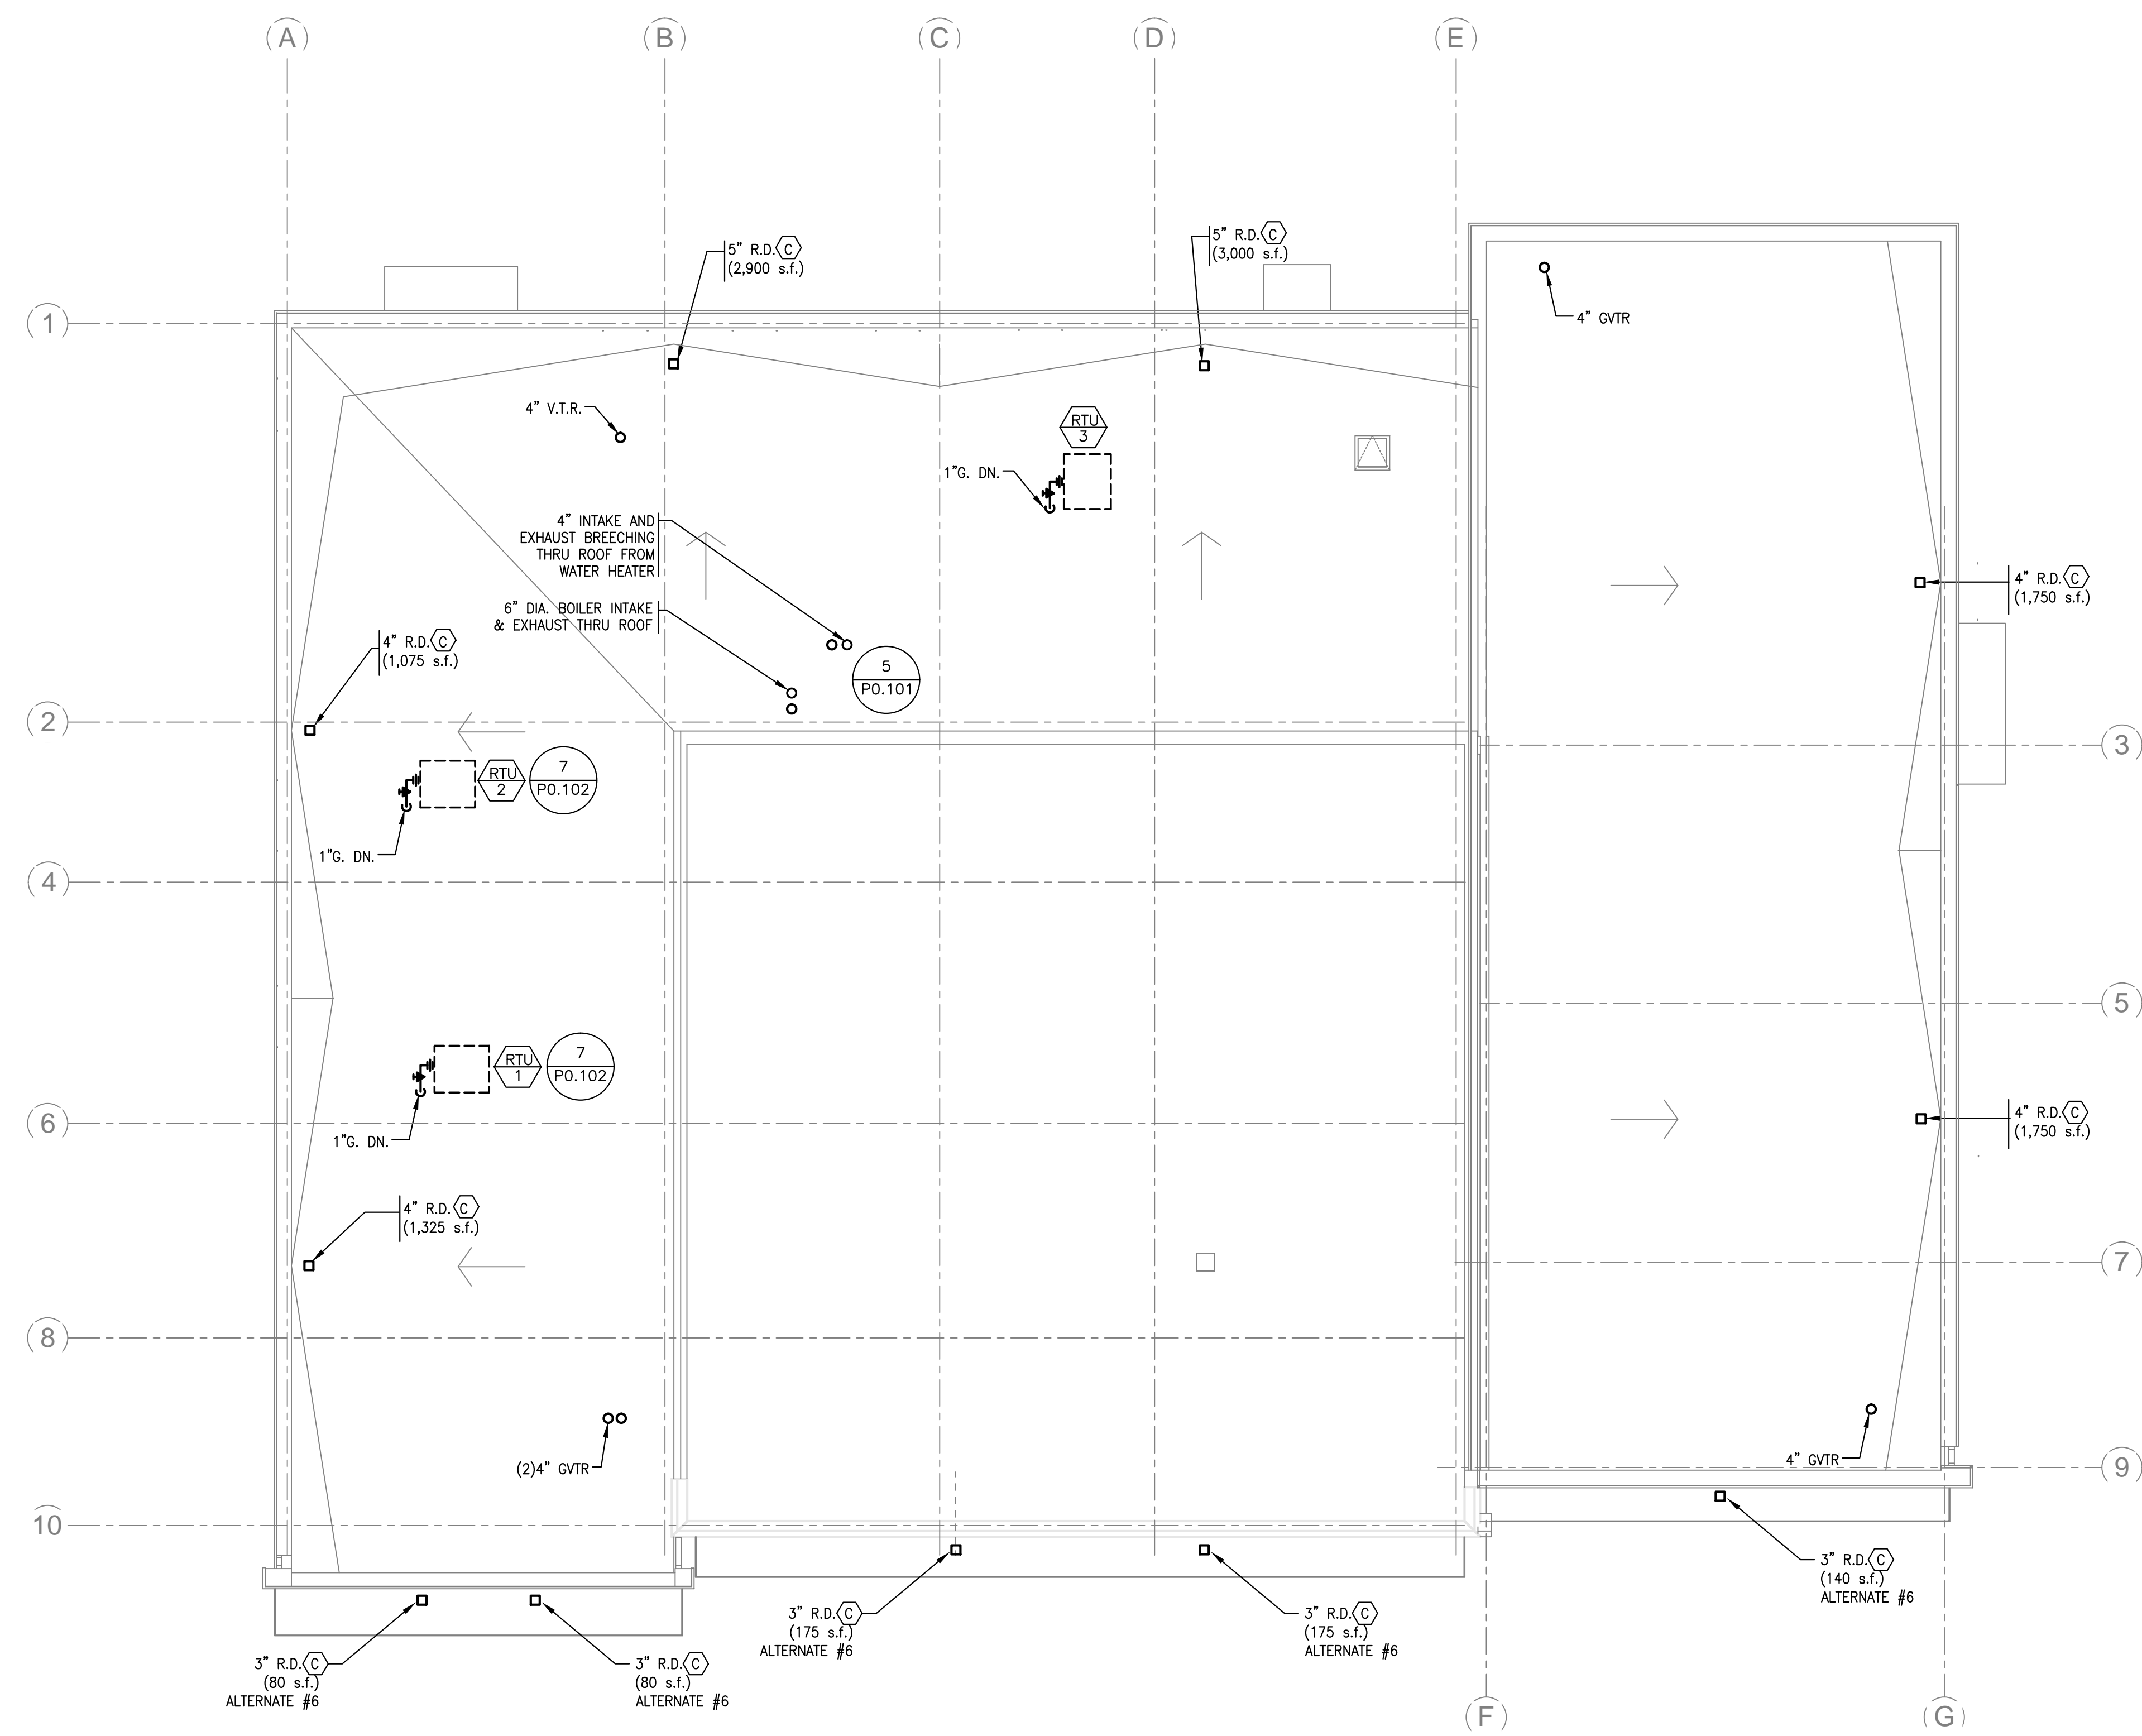

1 ROOF PLAN -- PLUMBING
SCALE: 1/8" = 1'-0"